


Legend:

- ⊗ Spotlight 10W LED–Type A
- 600X600 LED panel 40W–Type B
- ⊖ Bulkhead 9W LED–Type C
- LED Batten waterproof 20W–Type D
- LED Batten waterproof 10W–Type D
- ⓔ Emergency light 3W LED–Type E
- Ⓐ LED Floodlight 50W (with sensor)–Type F
- ⊙ Downlight 8W LED–Type G
- ↗ Switch 1 gang 1 way
- ↘ Switch 2 gang 1 way
- ↗ Dimmer Switch for Spotlight
- ↗ Switch 1 gang 1 way waterproof

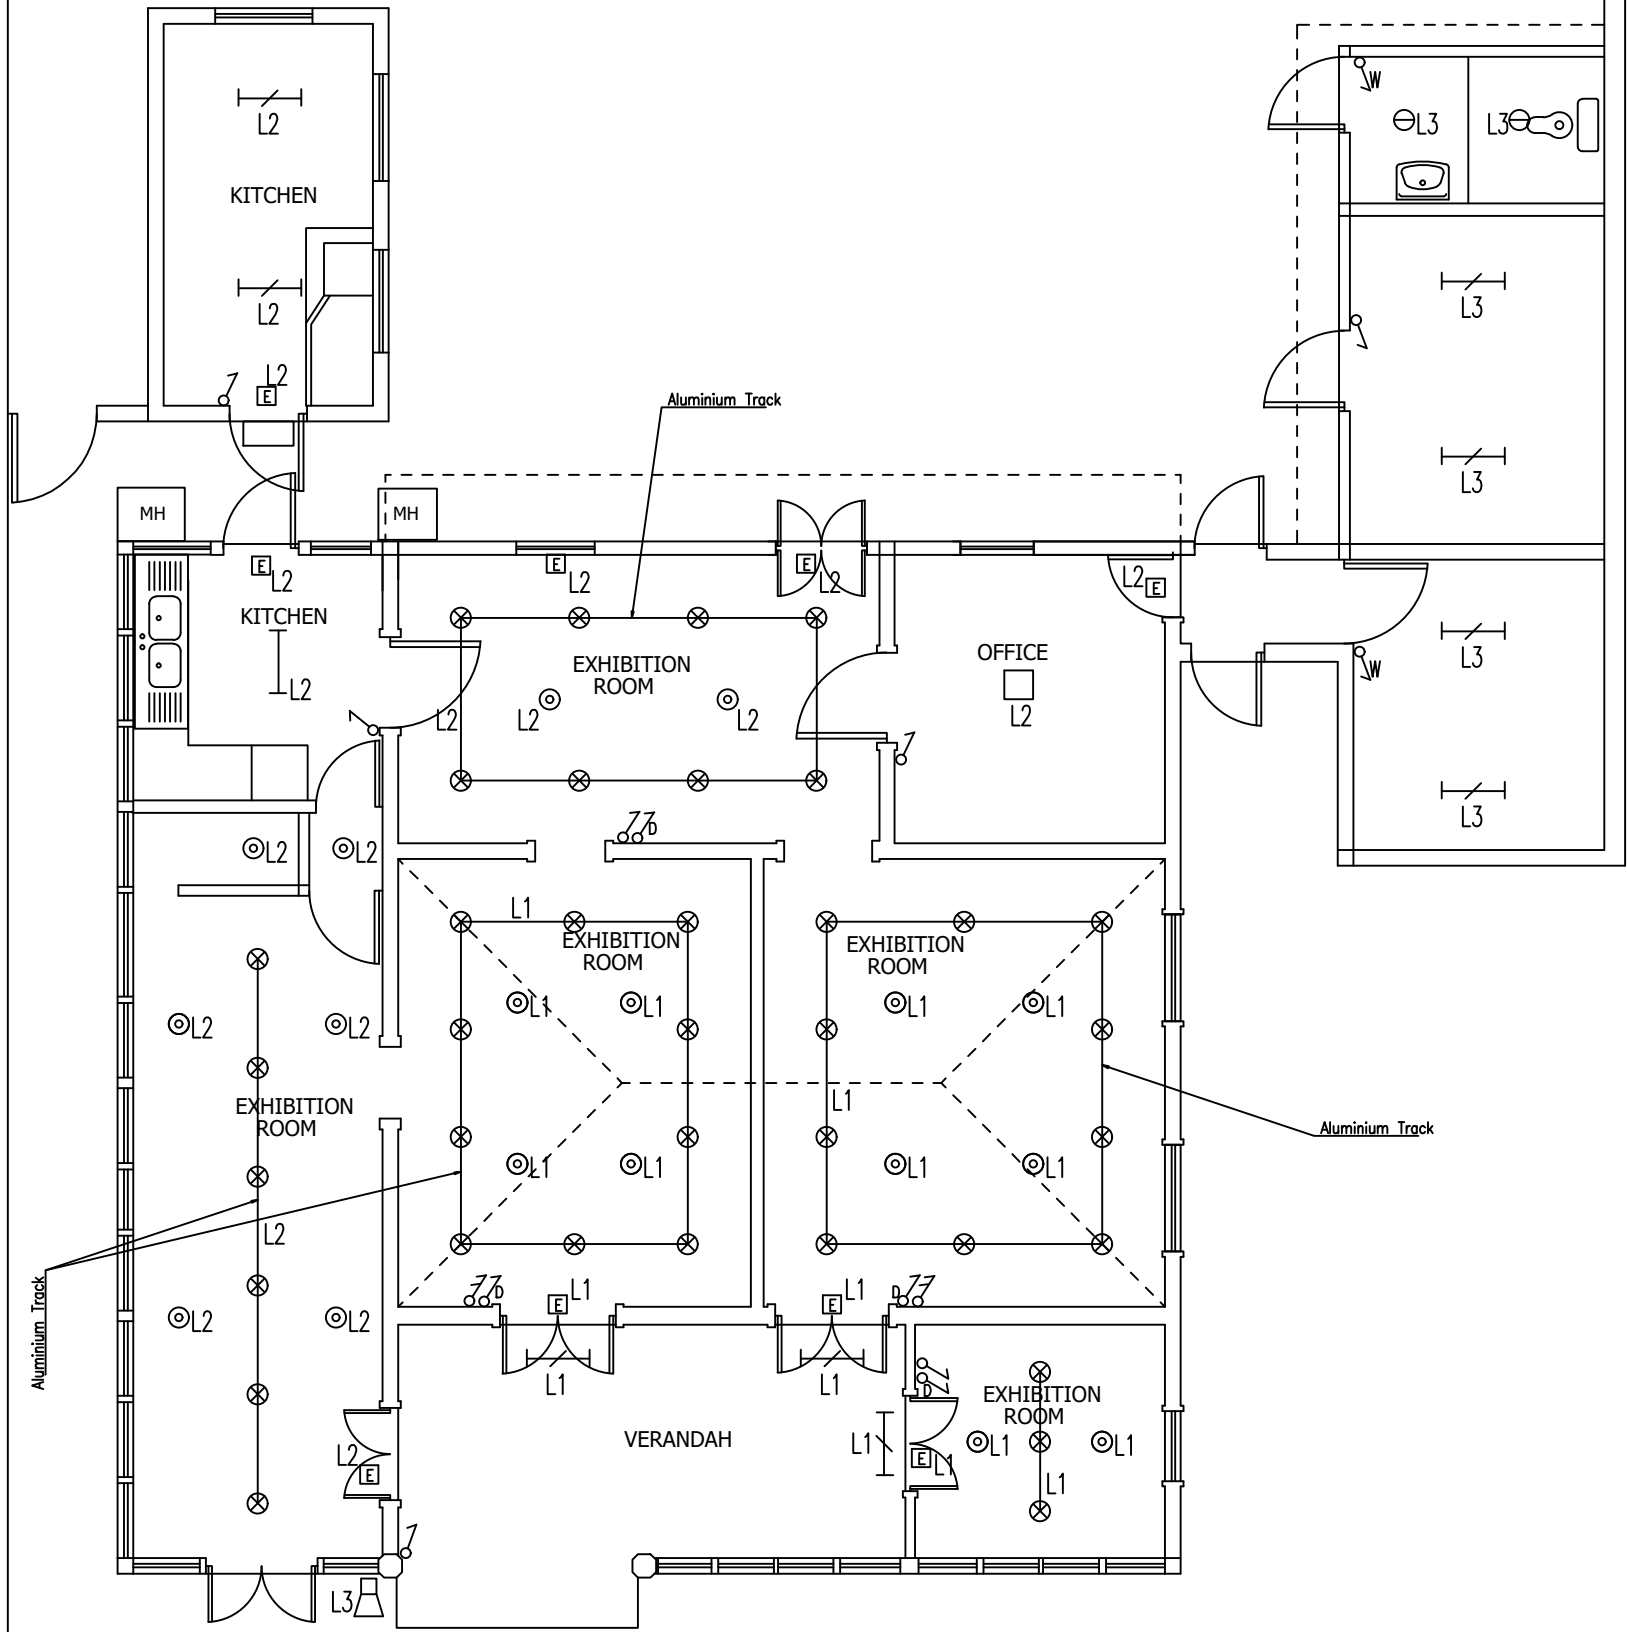

LIGHTING LAYOUT

|                                                                           |                  |
|---------------------------------------------------------------------------|------------------|
| Project                                                                   |                  |
| REFURBISHMENT WORKS AT<br>SSR MEMORIAL MUSEUM<br>SSR STREET<br>PORT-LOUIS |                  |
| Title                                                                     |                  |
| LIGHTING LAYOUT                                                           |                  |
| Project Coordinator                                                       | R. Canhyee       |
| Architect/S.Architect                                                     | J. Roja          |
| Engineer/S.Engineer                                                       | R. Harah         |
| Electrical/S.Elect.Eng.                                                   | S. Boodoo        |
| Quantity Surveyor                                                         | H. Rambhojun     |
| Technical Officer                                                         | R. Ramsurrun     |
| Tech. Desn. Officer                                                       | Y.P. Vythelingum |
| Scale: 1 : 50                                                             | Date: 22.03.2022 |
| MINISTRY OF NATIONAL INFRASTRUCTURE & COMMUNITY DEVELOPMENT<br>PHENIX     | Comp. No.<br>S   |
| DRG. No. RFW/EL02                                                         | Revision         |