


- Legend:
- Ⓢ Smoke detector
 - Ⓜ Heat detector
 - FAP Fire Alarm Panel
 - Manual call point
 - ◁_{LIS} Low Intensity Sounder

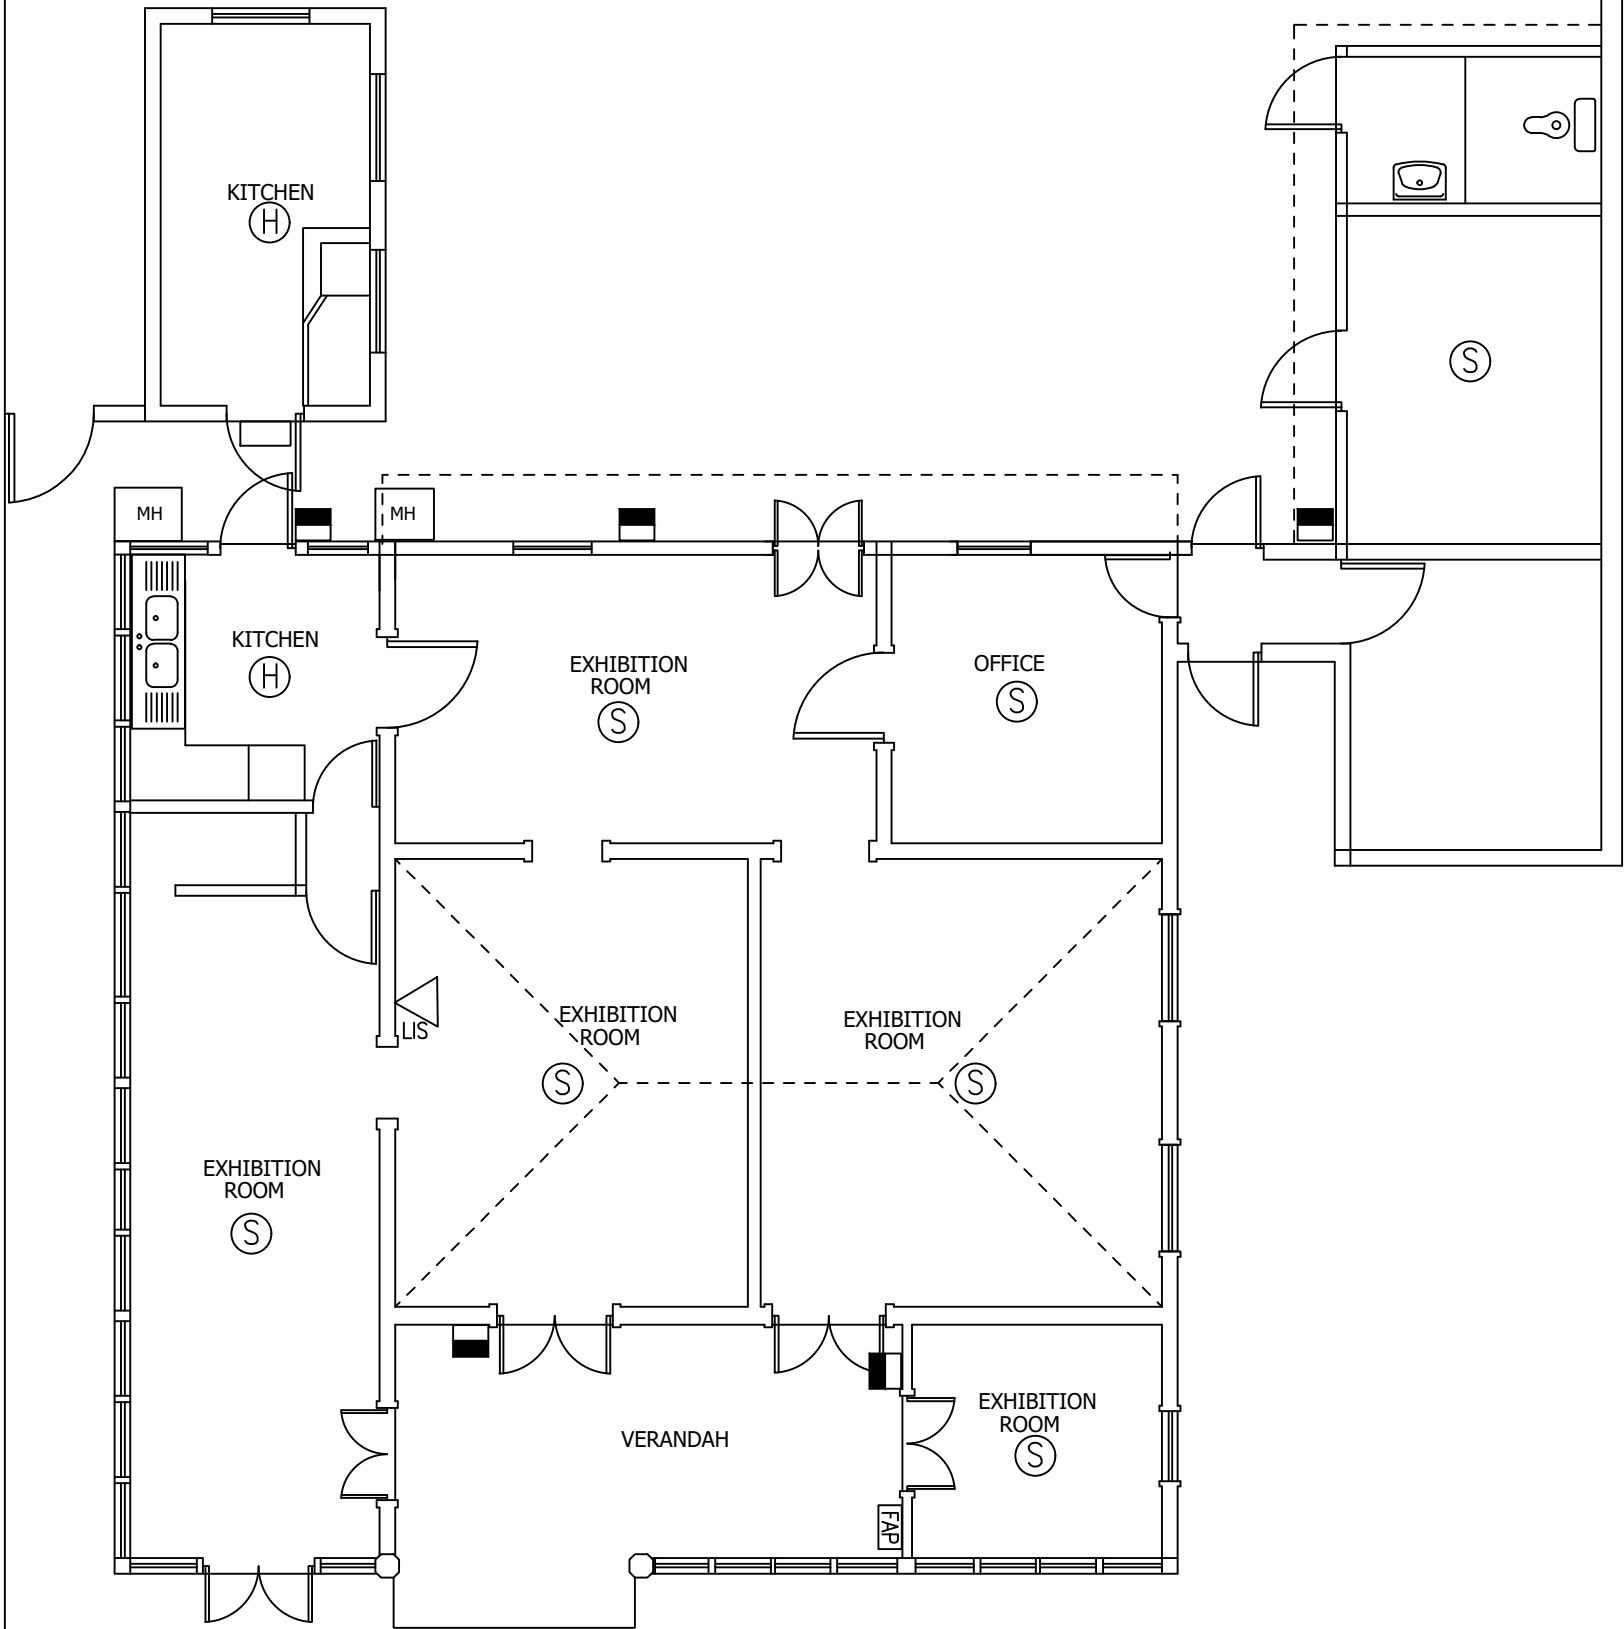

FIRE ALARM LAYOUT

Project	
REFURBISHMENT WORKS AT SSR MEMORIAL MUSEUM SSR STREET PORT-LOUIS	
Title	
FIRE ALARM LAYOUT	
Project Coordinator	R. Canhyee
Architect/S.Architect	J. Roja
Engineer/S.Engineer	R. Harah
Electrical/S.Elect.Eng.	S. Boodoo
Quantity Surveyor	H. Rambhojun
Technical Officer	R. Ramsurrun
Tech. Desn. Officer	Y.P. Vythelingum
Scale: 1 : 50	Date: 22.03.2022
MINISTRY OF NATIONAL INFRASTRUCTURE & COMMUNITY DEVELOPMENT PHOENIX	
DRG. No. RFW/EL04	
Comp. No. S	Revision