



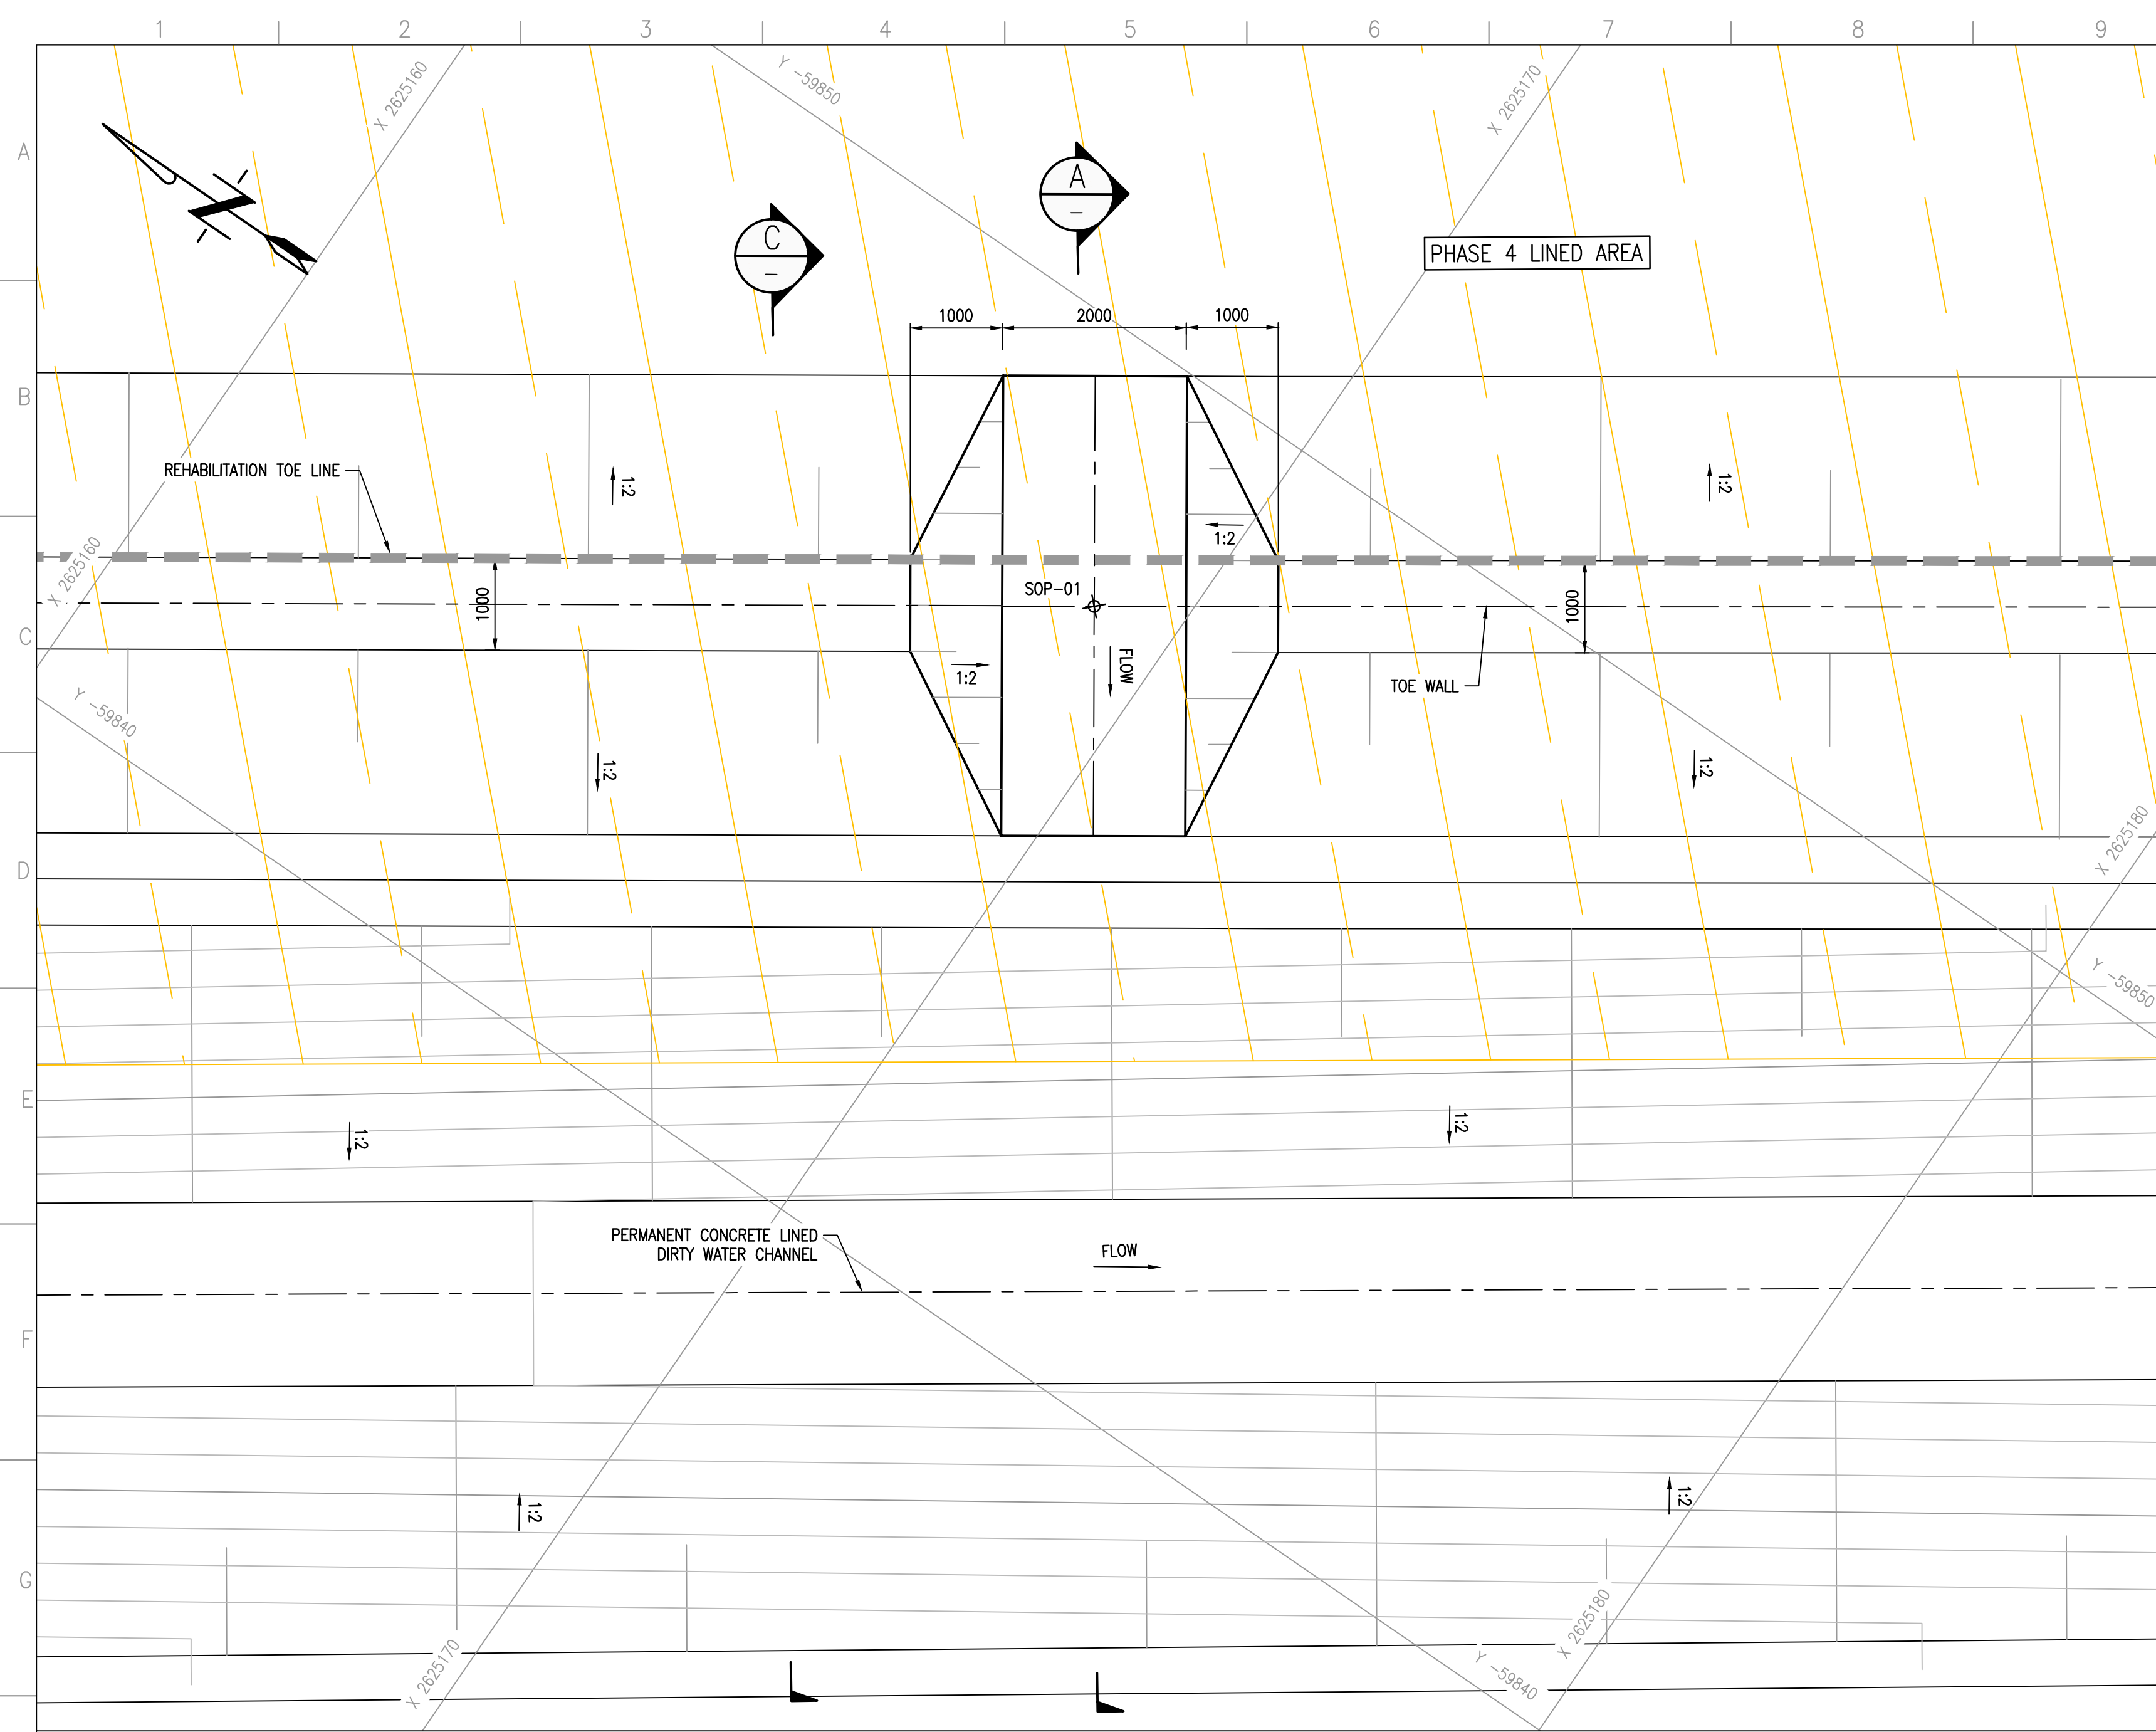


1 SPILLWAY 4A LAYOUT PLAN
SCALE 1:50

SPILLWAYS
SETTING OUT DATA
(Lo27 WGS84)


POINT	X	Y
SOP-01	2625169.098	-59847.326
SOP-02	2625070.473	-59779.047

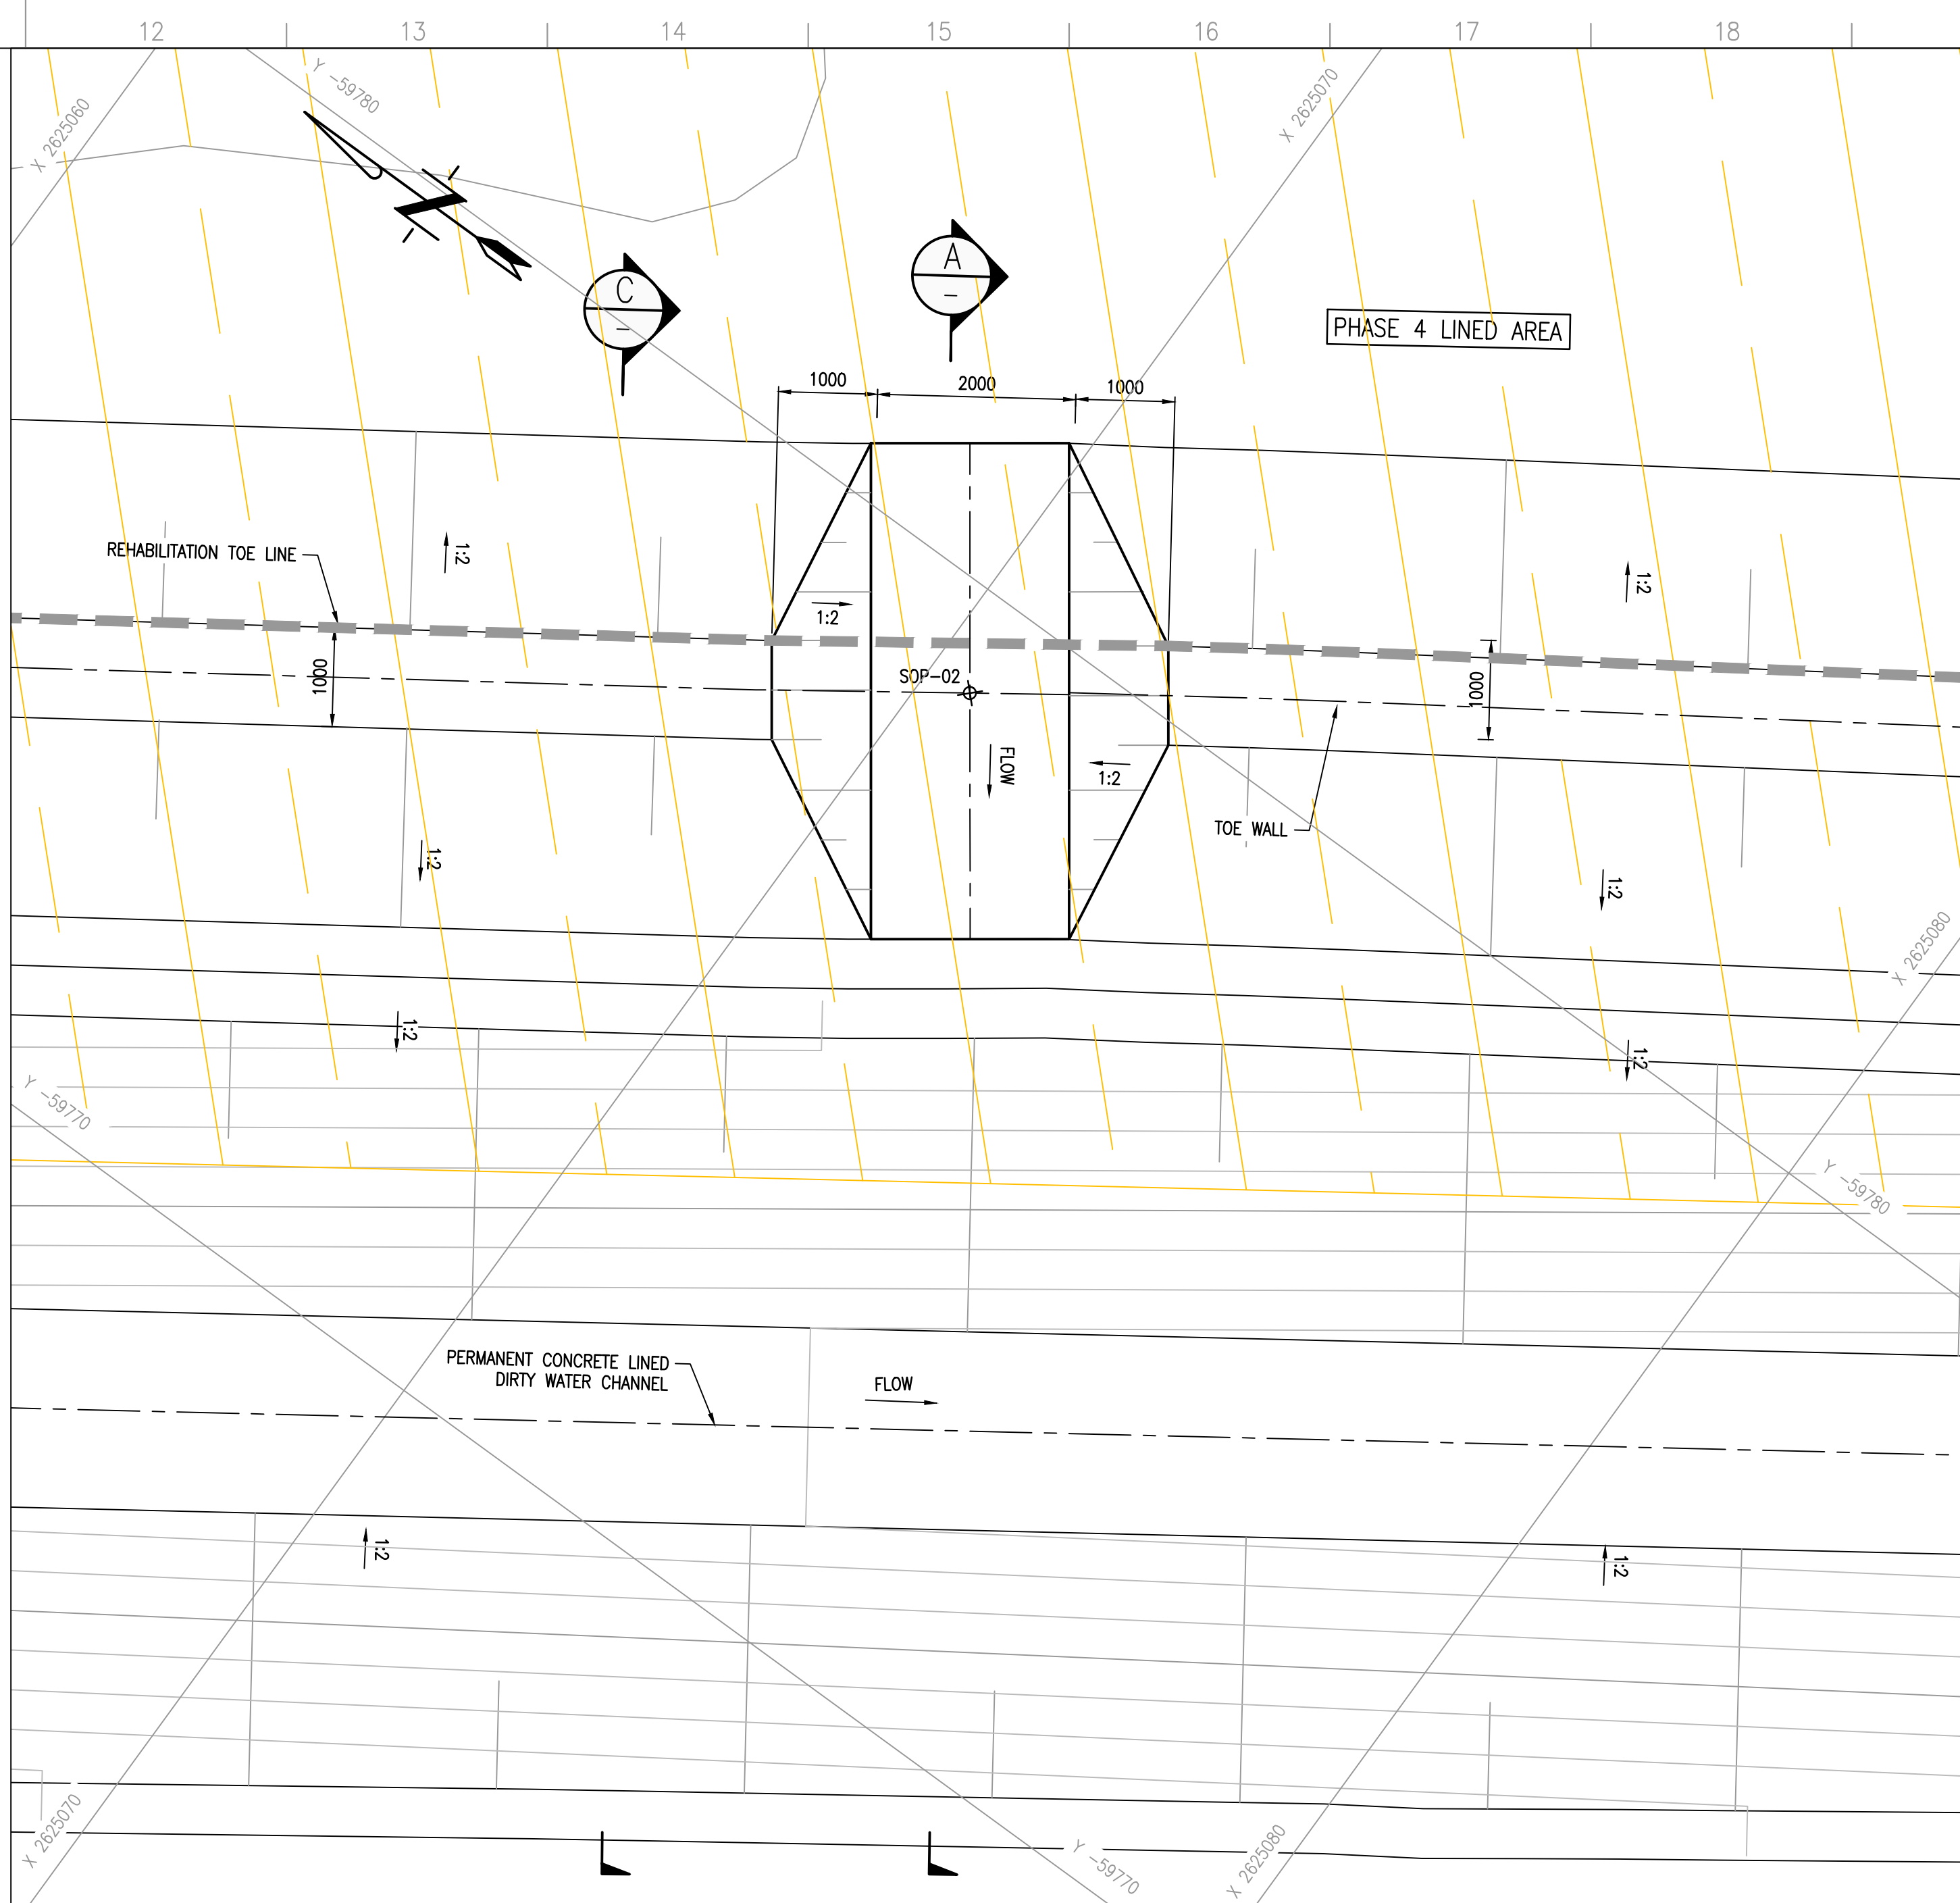


2 SPILLWAY 4B LAYOUT PLAN
SCALE 1:50

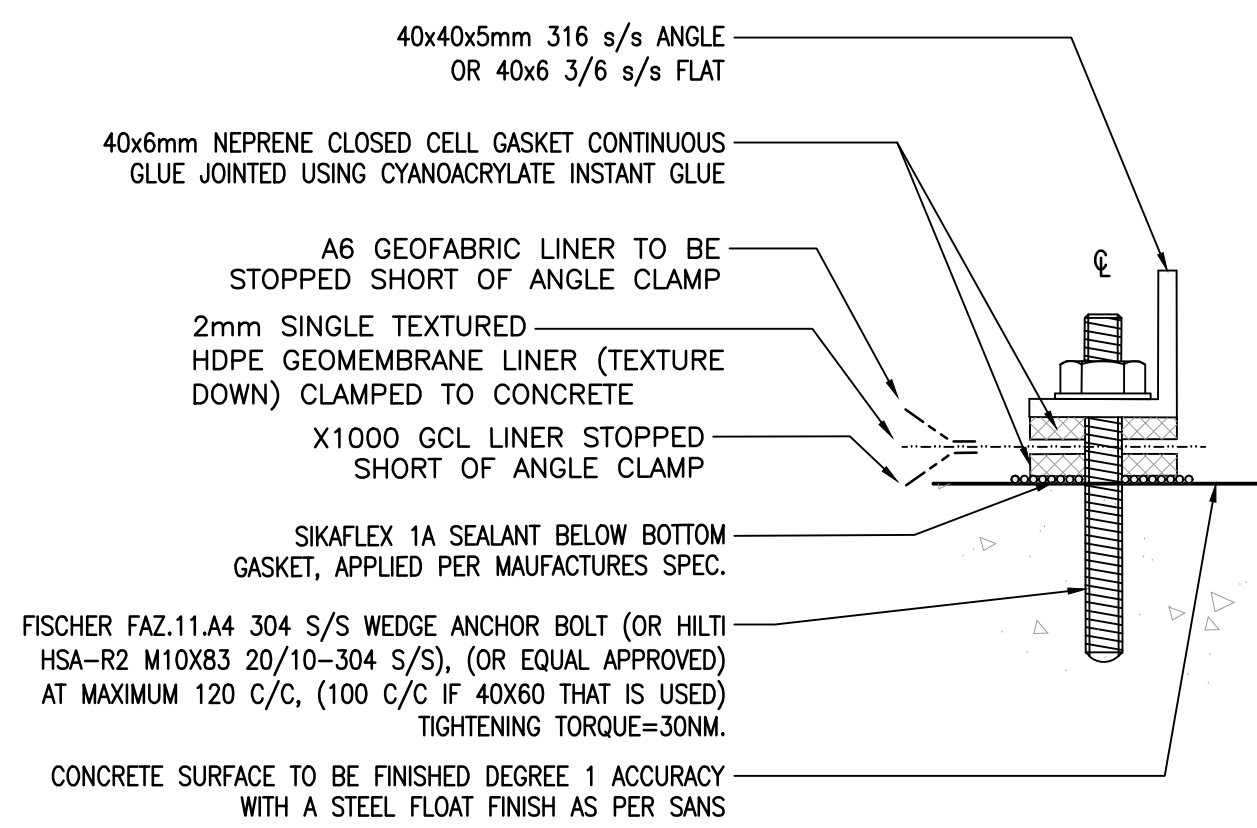


3 LINER SYSTEM FIXING DETAIL
SCALE 1:2

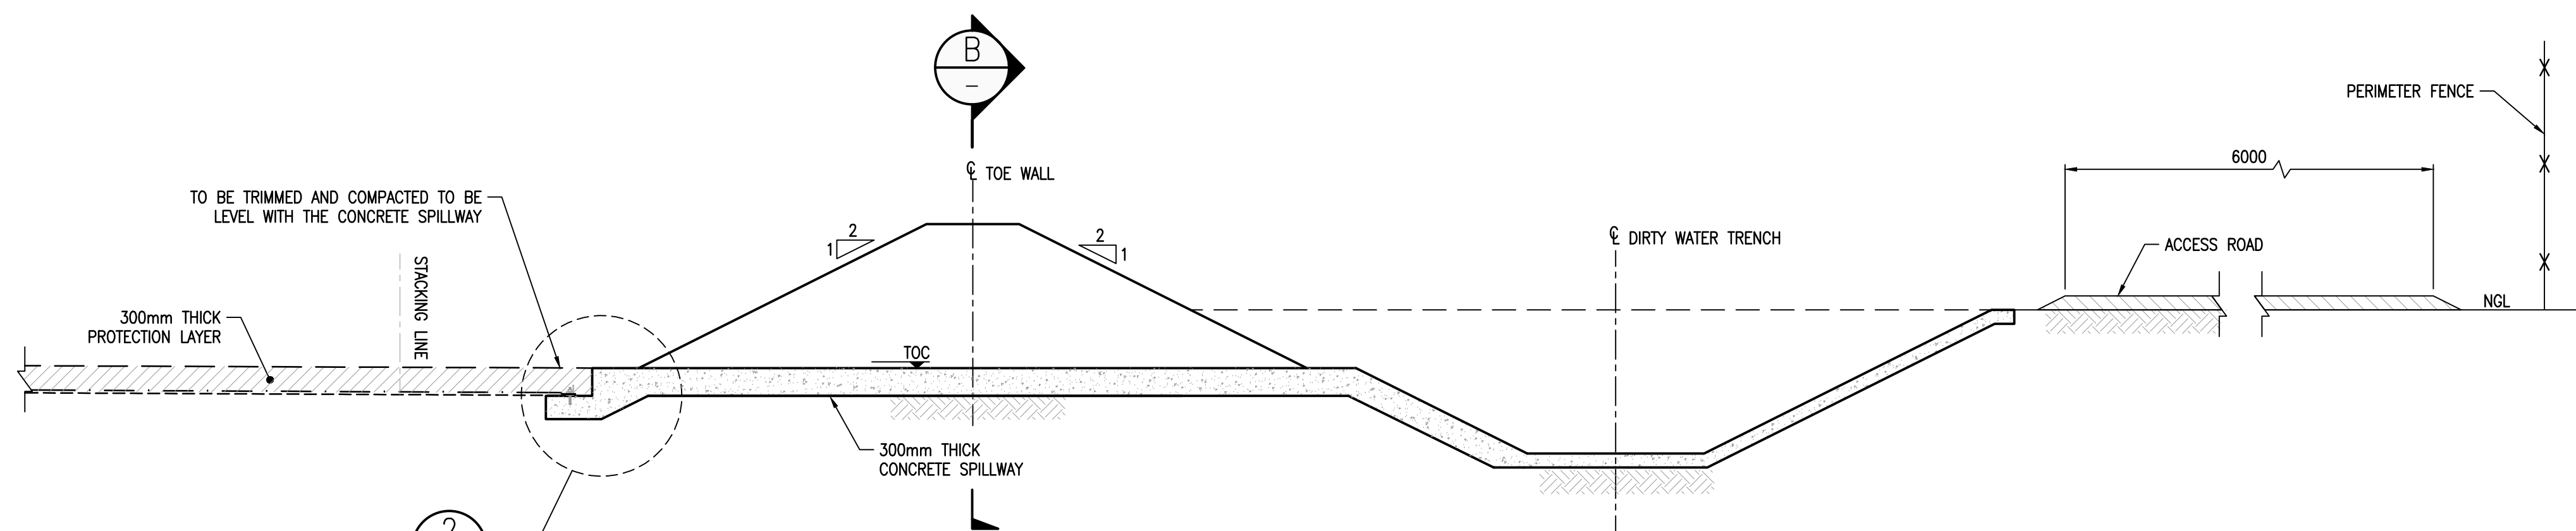


A TYPICAL WEIR SECTION
SCALE 1:50

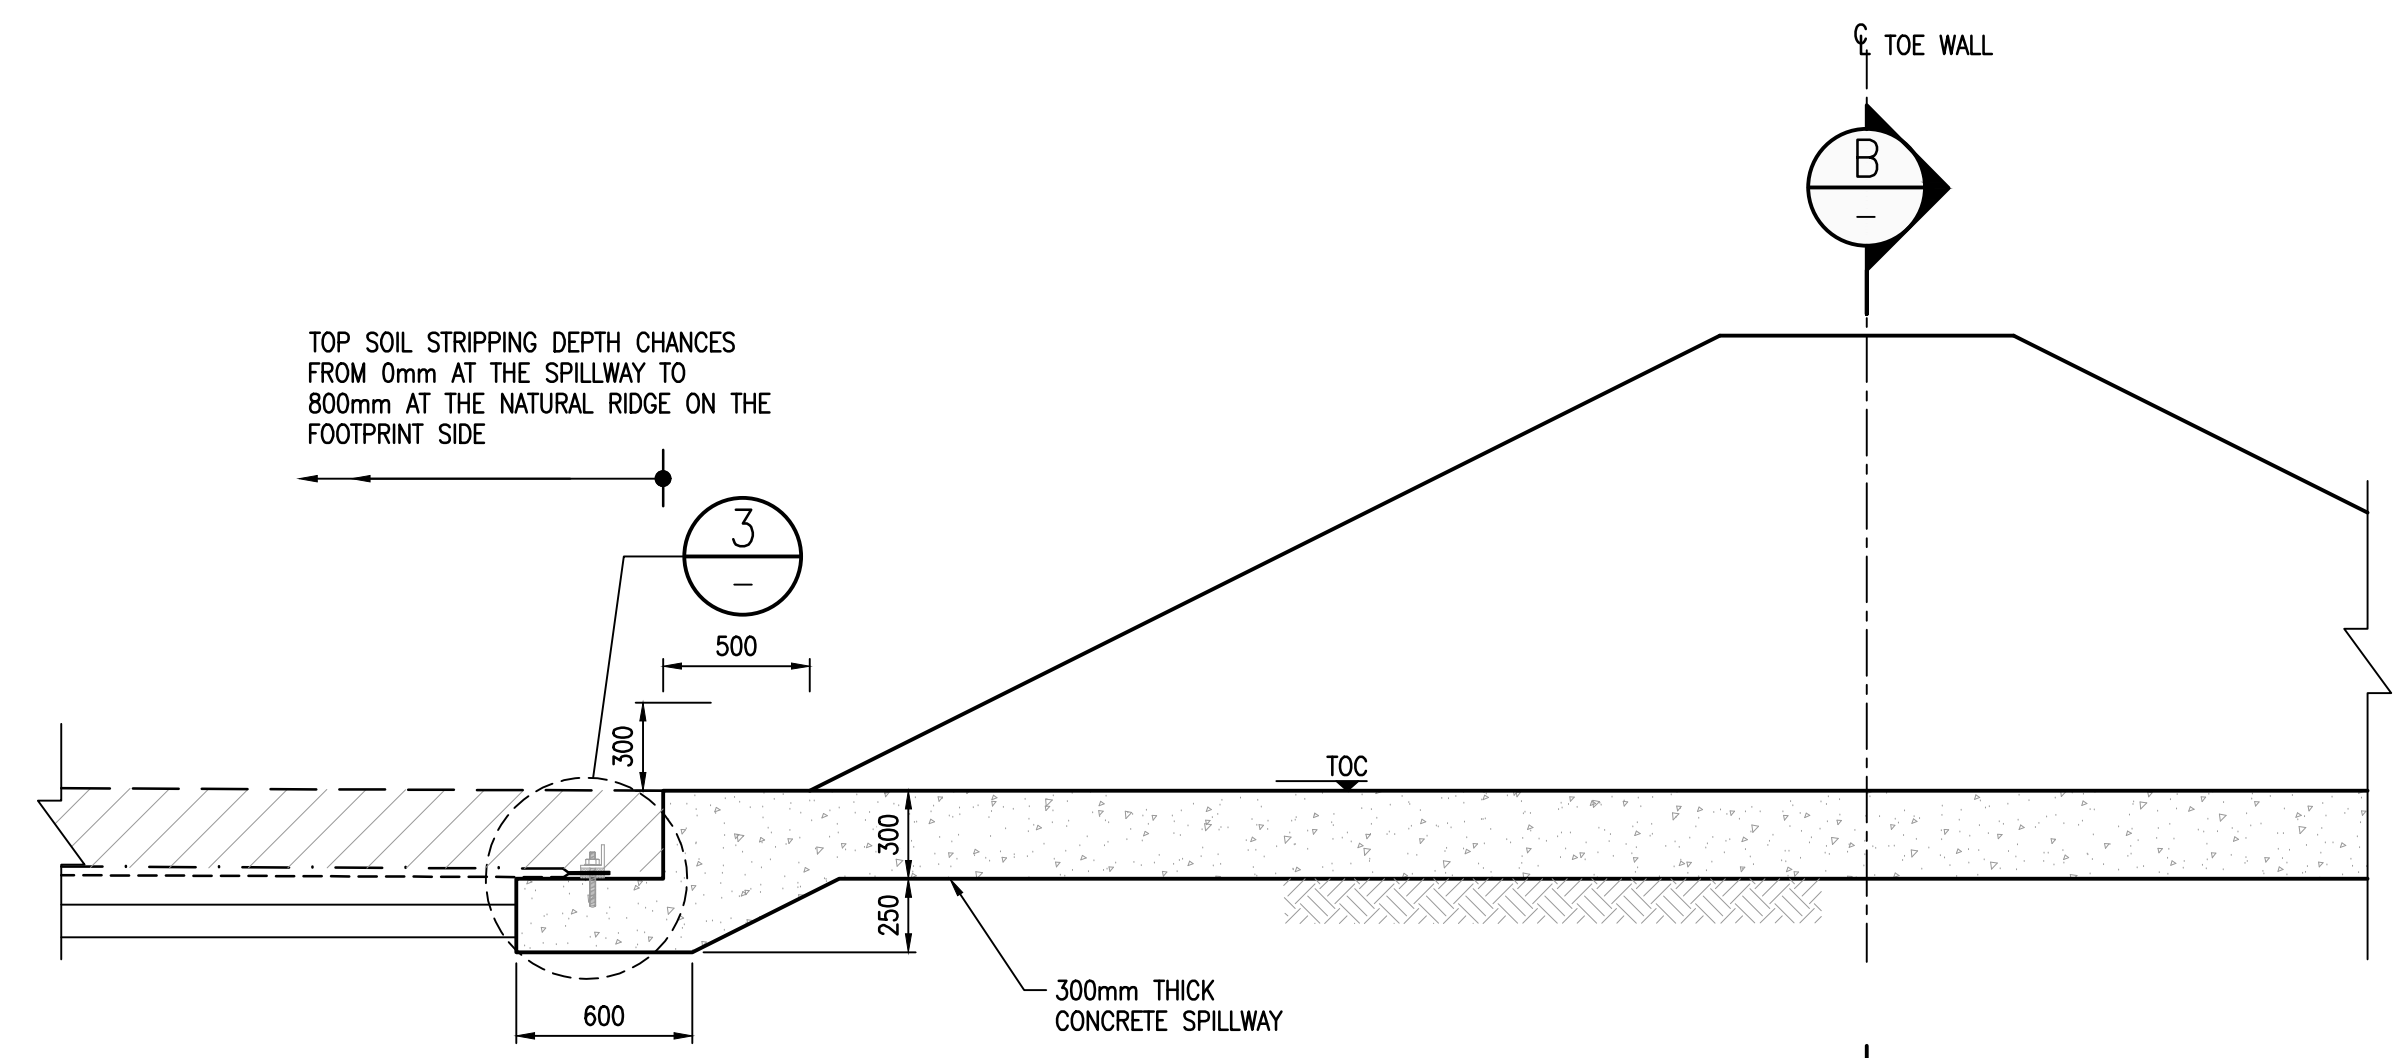


2 TYPICAL DETAIL
SCALE 1:25

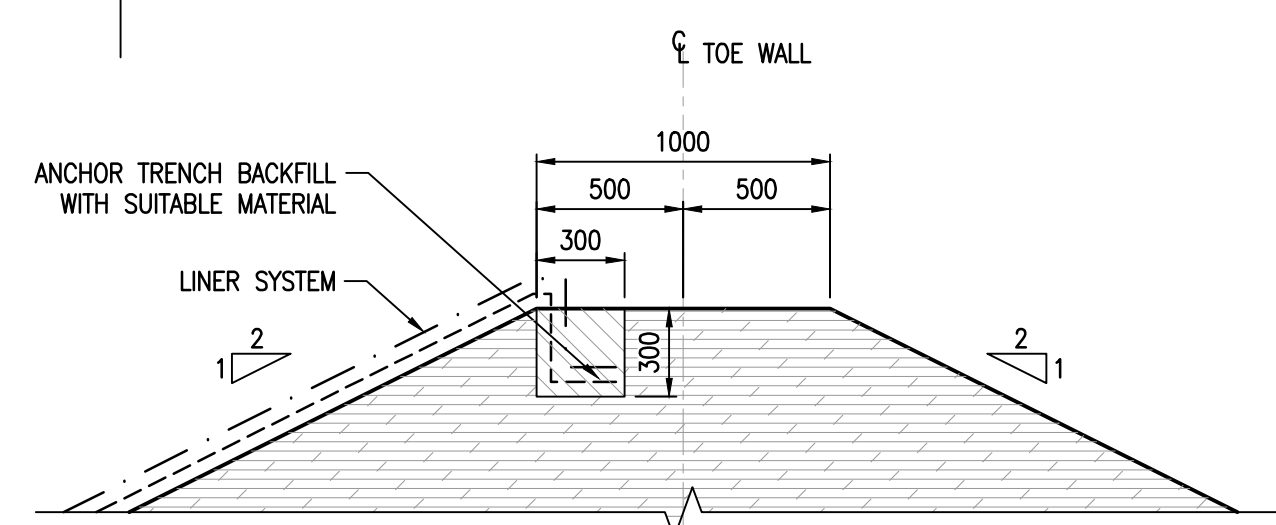


4 ANCHOR TRENCH
SCALE 1:25

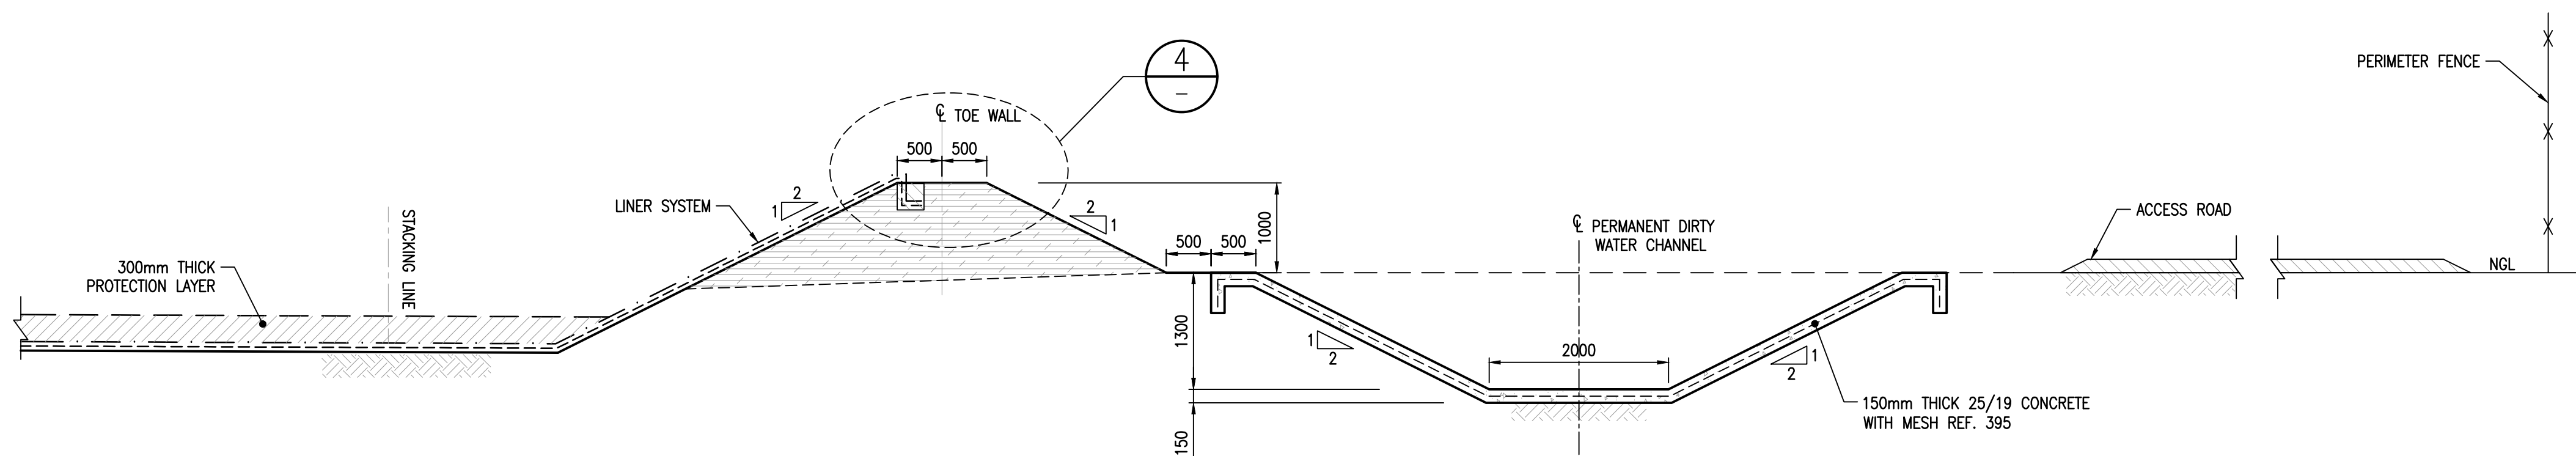

C TYPICAL TOE WALL SECTION
SCALE 1:50

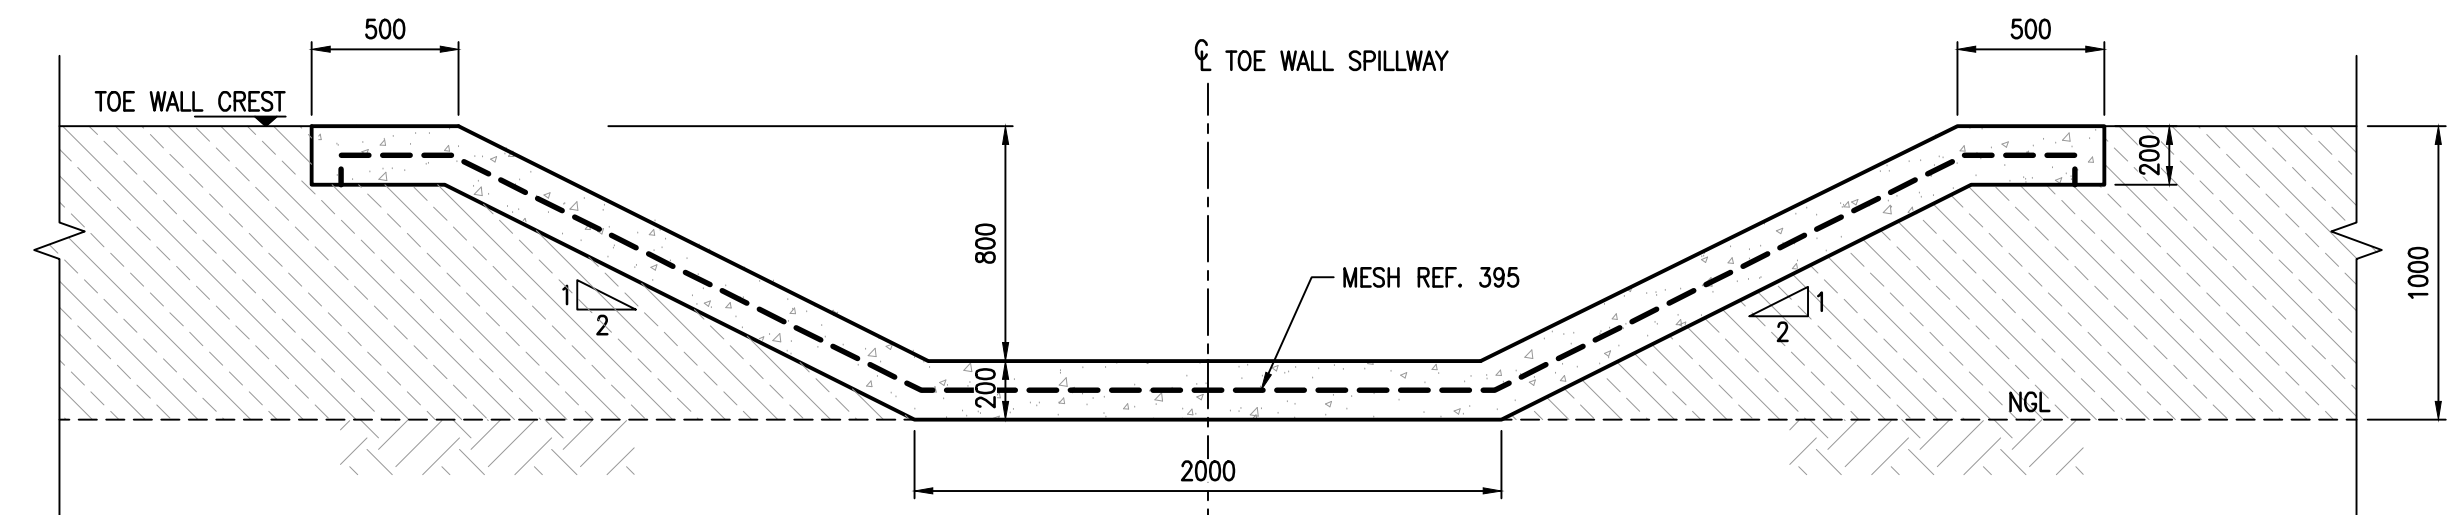

B TYPICAL SPILLWAY SECTION
SCALE 1:25

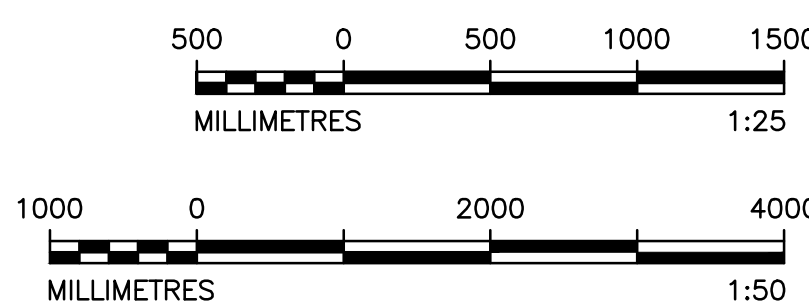

FOR CONSTRUCTION

DISCLAIMER
This drawing was prepared by Knight Piesold Consulting (Pty) Ltd based on the best information available at the time of preparation. During construction site conditions, or site conditions, or site development, may possibly dictate that amendments or adaptations be made to certain details on the drawing. Strict compliance with the project specifications is also essential. Knight Piesold Consulting (Pty) Ltd will therefore not accept liability for any losses, damages or consequential losses, suffered by any party resulting from the use or implementation of the contents of this drawing, if executed or amended without fulltime supervision by Knight Piesold Consulting (Pty) Ltd.

REV	NO	DATE	BY	APP	CHK	REF
2	00825/01-407	2022/05/27	JK	TM	JRW	
1	00825/01-407	2022/05/27	JK	TM	JRW	
0	00825/01-407	2022/05/27	JK	TM	JRW	
REFERENCE DRAWINGS						
MATIMBA POWER STATION						
MATIMBA ASH DUMP						
PHASE 4 (16 YEARS LINED AREA)						
SPILLWAYS						
LAYOUT PLAN, SECTIONS AND DETAILS						
301-00825/01-407						
0.58/61417						
SHT 8						
REV 2						
REV 2						
SCALE AS SHOWN						