



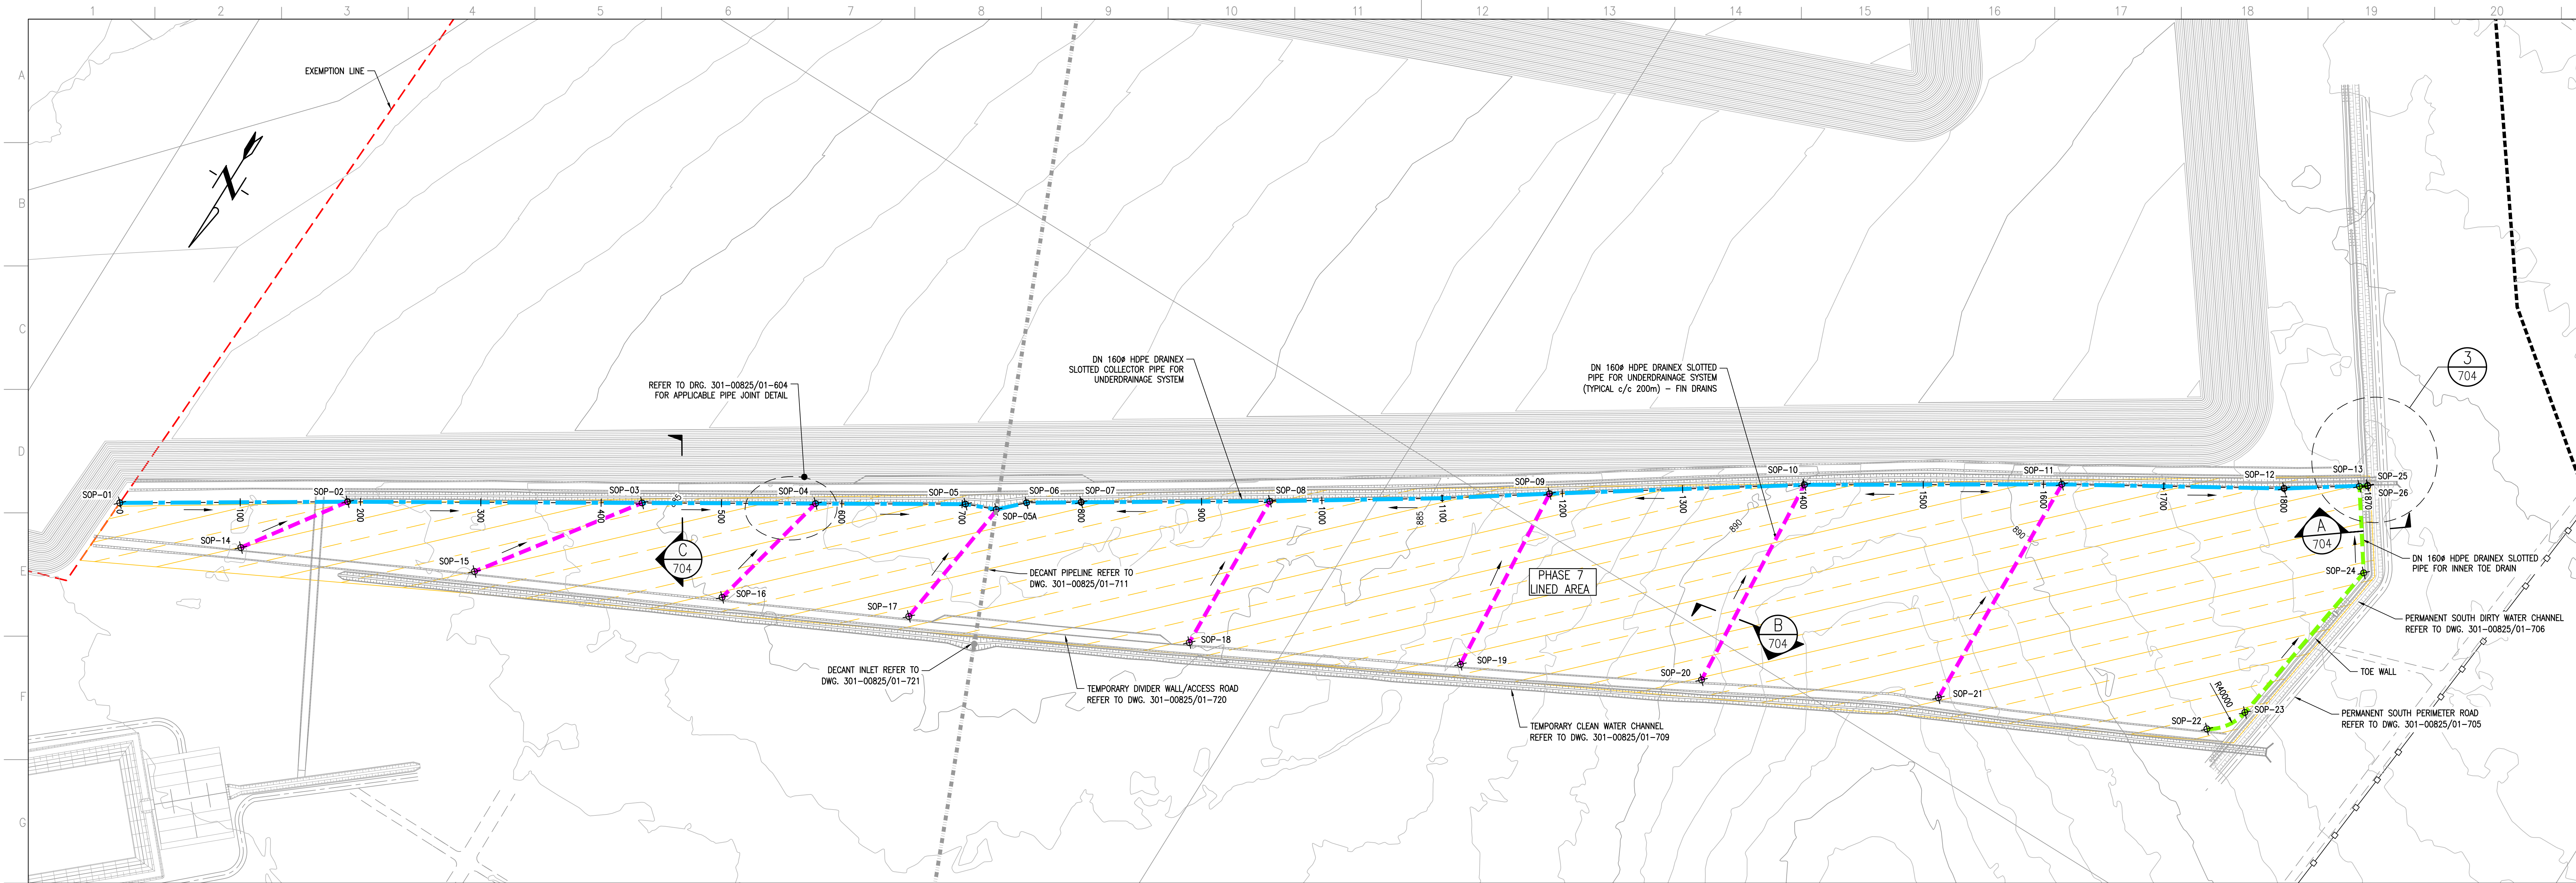


UNDERDRAINAGE LINER SYSTEM LAYOUT PLAN
SCALE 1:2000

UNDERDRAINAGE SETTING OUT DATA (Lo27 WGS84)		
POINT	X	Y
SOP-01	2623395.177	-60886.180
SOP-02	2623495.960	-60725.936
SOP-03	2623624.360	-60517.572
SOP-04	2623700.055	-60394.901
SOP-05	2623765.517	-60288.814
SOP-06	2623775.222	-60264.788
SOP-07	2623793.270	-60246.320
SOP-08	2623817.657	-60208.014
SOP-09	2623901.191	-60075.273
SOP-10	2624029.282	-59881.237
SOP-11	2624147.399	-59705.260
SOP-12	2624260.821	-59523.713
SOP-13	2624355.391	-59365.104
SOP-14	2624394.197	-59307.436
SOP-15	2624316.776	-59281.128
SOP-16	2623592.469	-60605.801
SOP-17	2623592.910	-60419.684
SOP-18	2623661.452	-60279.583
SOP-19	2623669.769	-60070.188
SOP-20	2623964.678	-59892.281
SOP-21	2624056.115	-59517.313
SOP-22	2624151.882	-59314.087
SOP-23	2624180.209	-59294.454
SOP-24	2624330.789	-59271.928
SOP-25	2624389.936	-59312.873
SOP-26	2624393.782	-59307.157

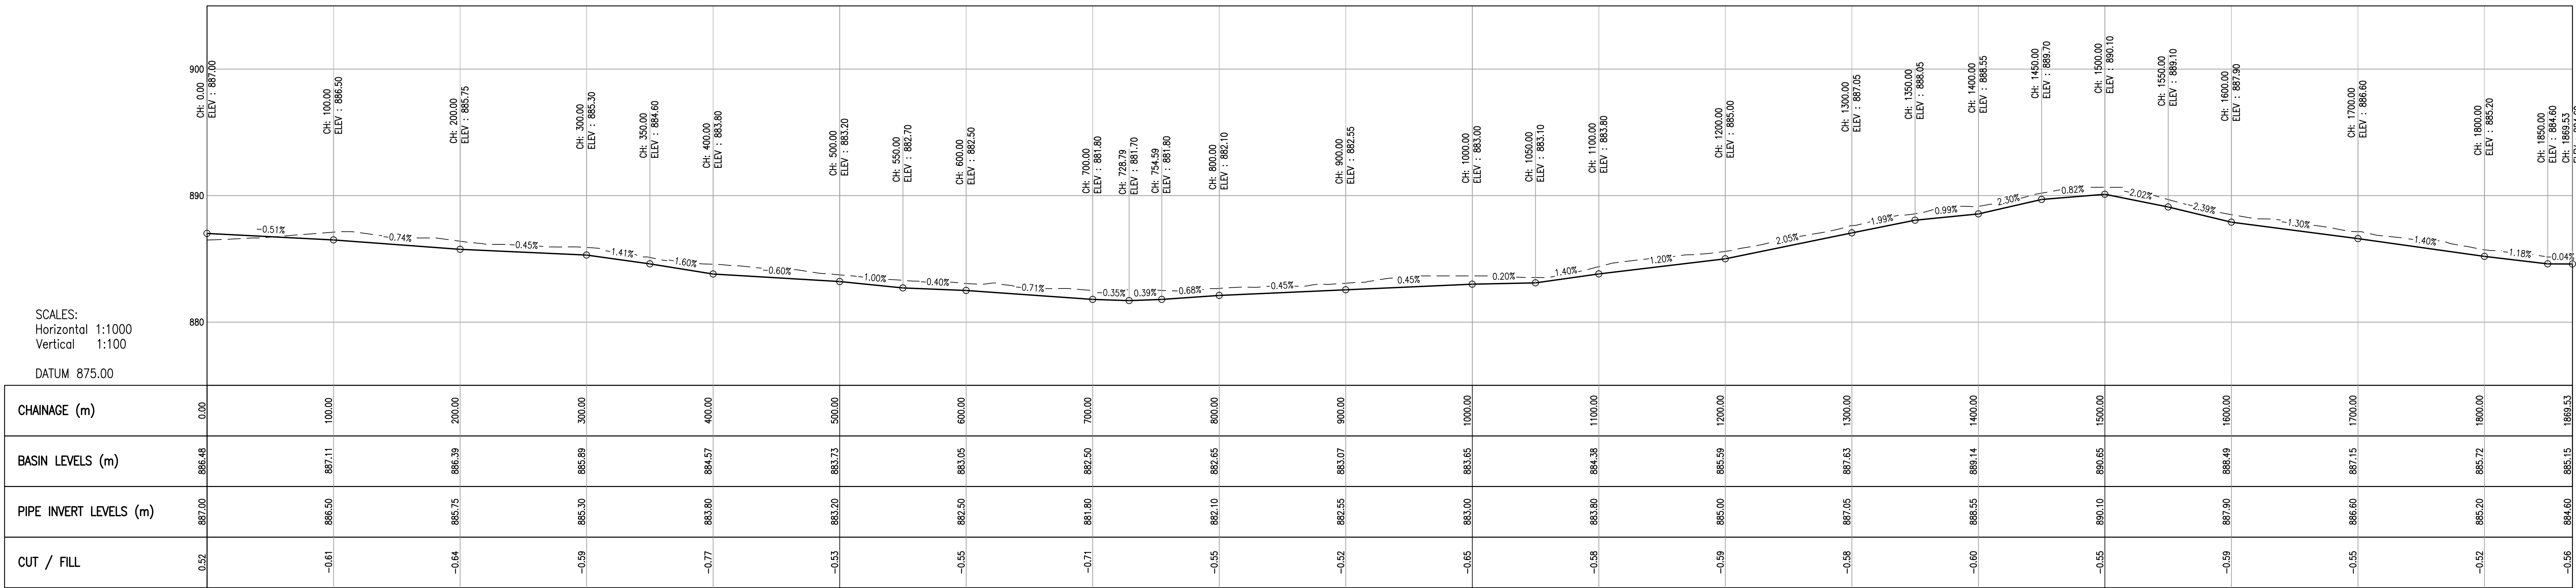

COLLECTION PIPE LONGITUDINAL SECTION
SCALE 1:2000

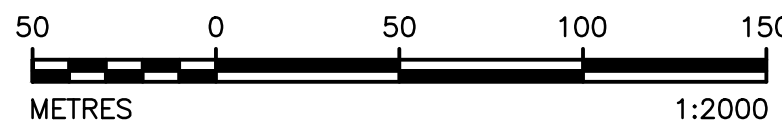

DISCLAIMER
This drawing was prepared by Knight Piesold Consulting (Pty) Ltd based on the best information available at the time of preparation. During construction site conditions, or site conditions, or site development, may possibly dictate that amendments or adaptations be made to certain details on the drawing. Strict compliance with the project specifications is also essential. Knight Piesold Consulting (Pty) Ltd will therefore not accept liability for any losses, damages or consequential losses, suffered by any party resulting from the use or implementation of the contents of this drawing, if executed or amended without full-time supervision by Knight Piesold Consulting (Pty) Ltd.

3	25.05.20	SETTING OUT POINTS AMENDED	MMK	TM	JRW				
2	25.05.20	ISSUED FOR CONSTRUCTION	MMK	TM	JRW				
D.O.	REV	DATE	REVISION	REV	BY	APP	AUTH	CHK	REFERENCE DRAWINGS
AUTHORISED FOR ESKOM BY:			CLASSIFICATION						
COORDINATION BY:			PES PATH						
APPROVED BY:			MATIMBA POWER STATION						
CREATED BY:			MATIMBA A SH DUMP						
CREATED BY:			PHASE 7 (28 YEARS LINED AREA)						
CREATED BY:			UNDERLAYMENT LINER SYSTEM						
CREATED BY:			DRAINAGE PLAN						
CREATED BY:			Eskom						
CREATED BY:			301-00825/01-703			REV 3			
CREATED BY:			ESKOM HEADQUARTERS LOGO						
CREATED BY:			0.58/61420			REV 3			
CREATED BY:			SCALE AS SHOWN			SHT 4			