



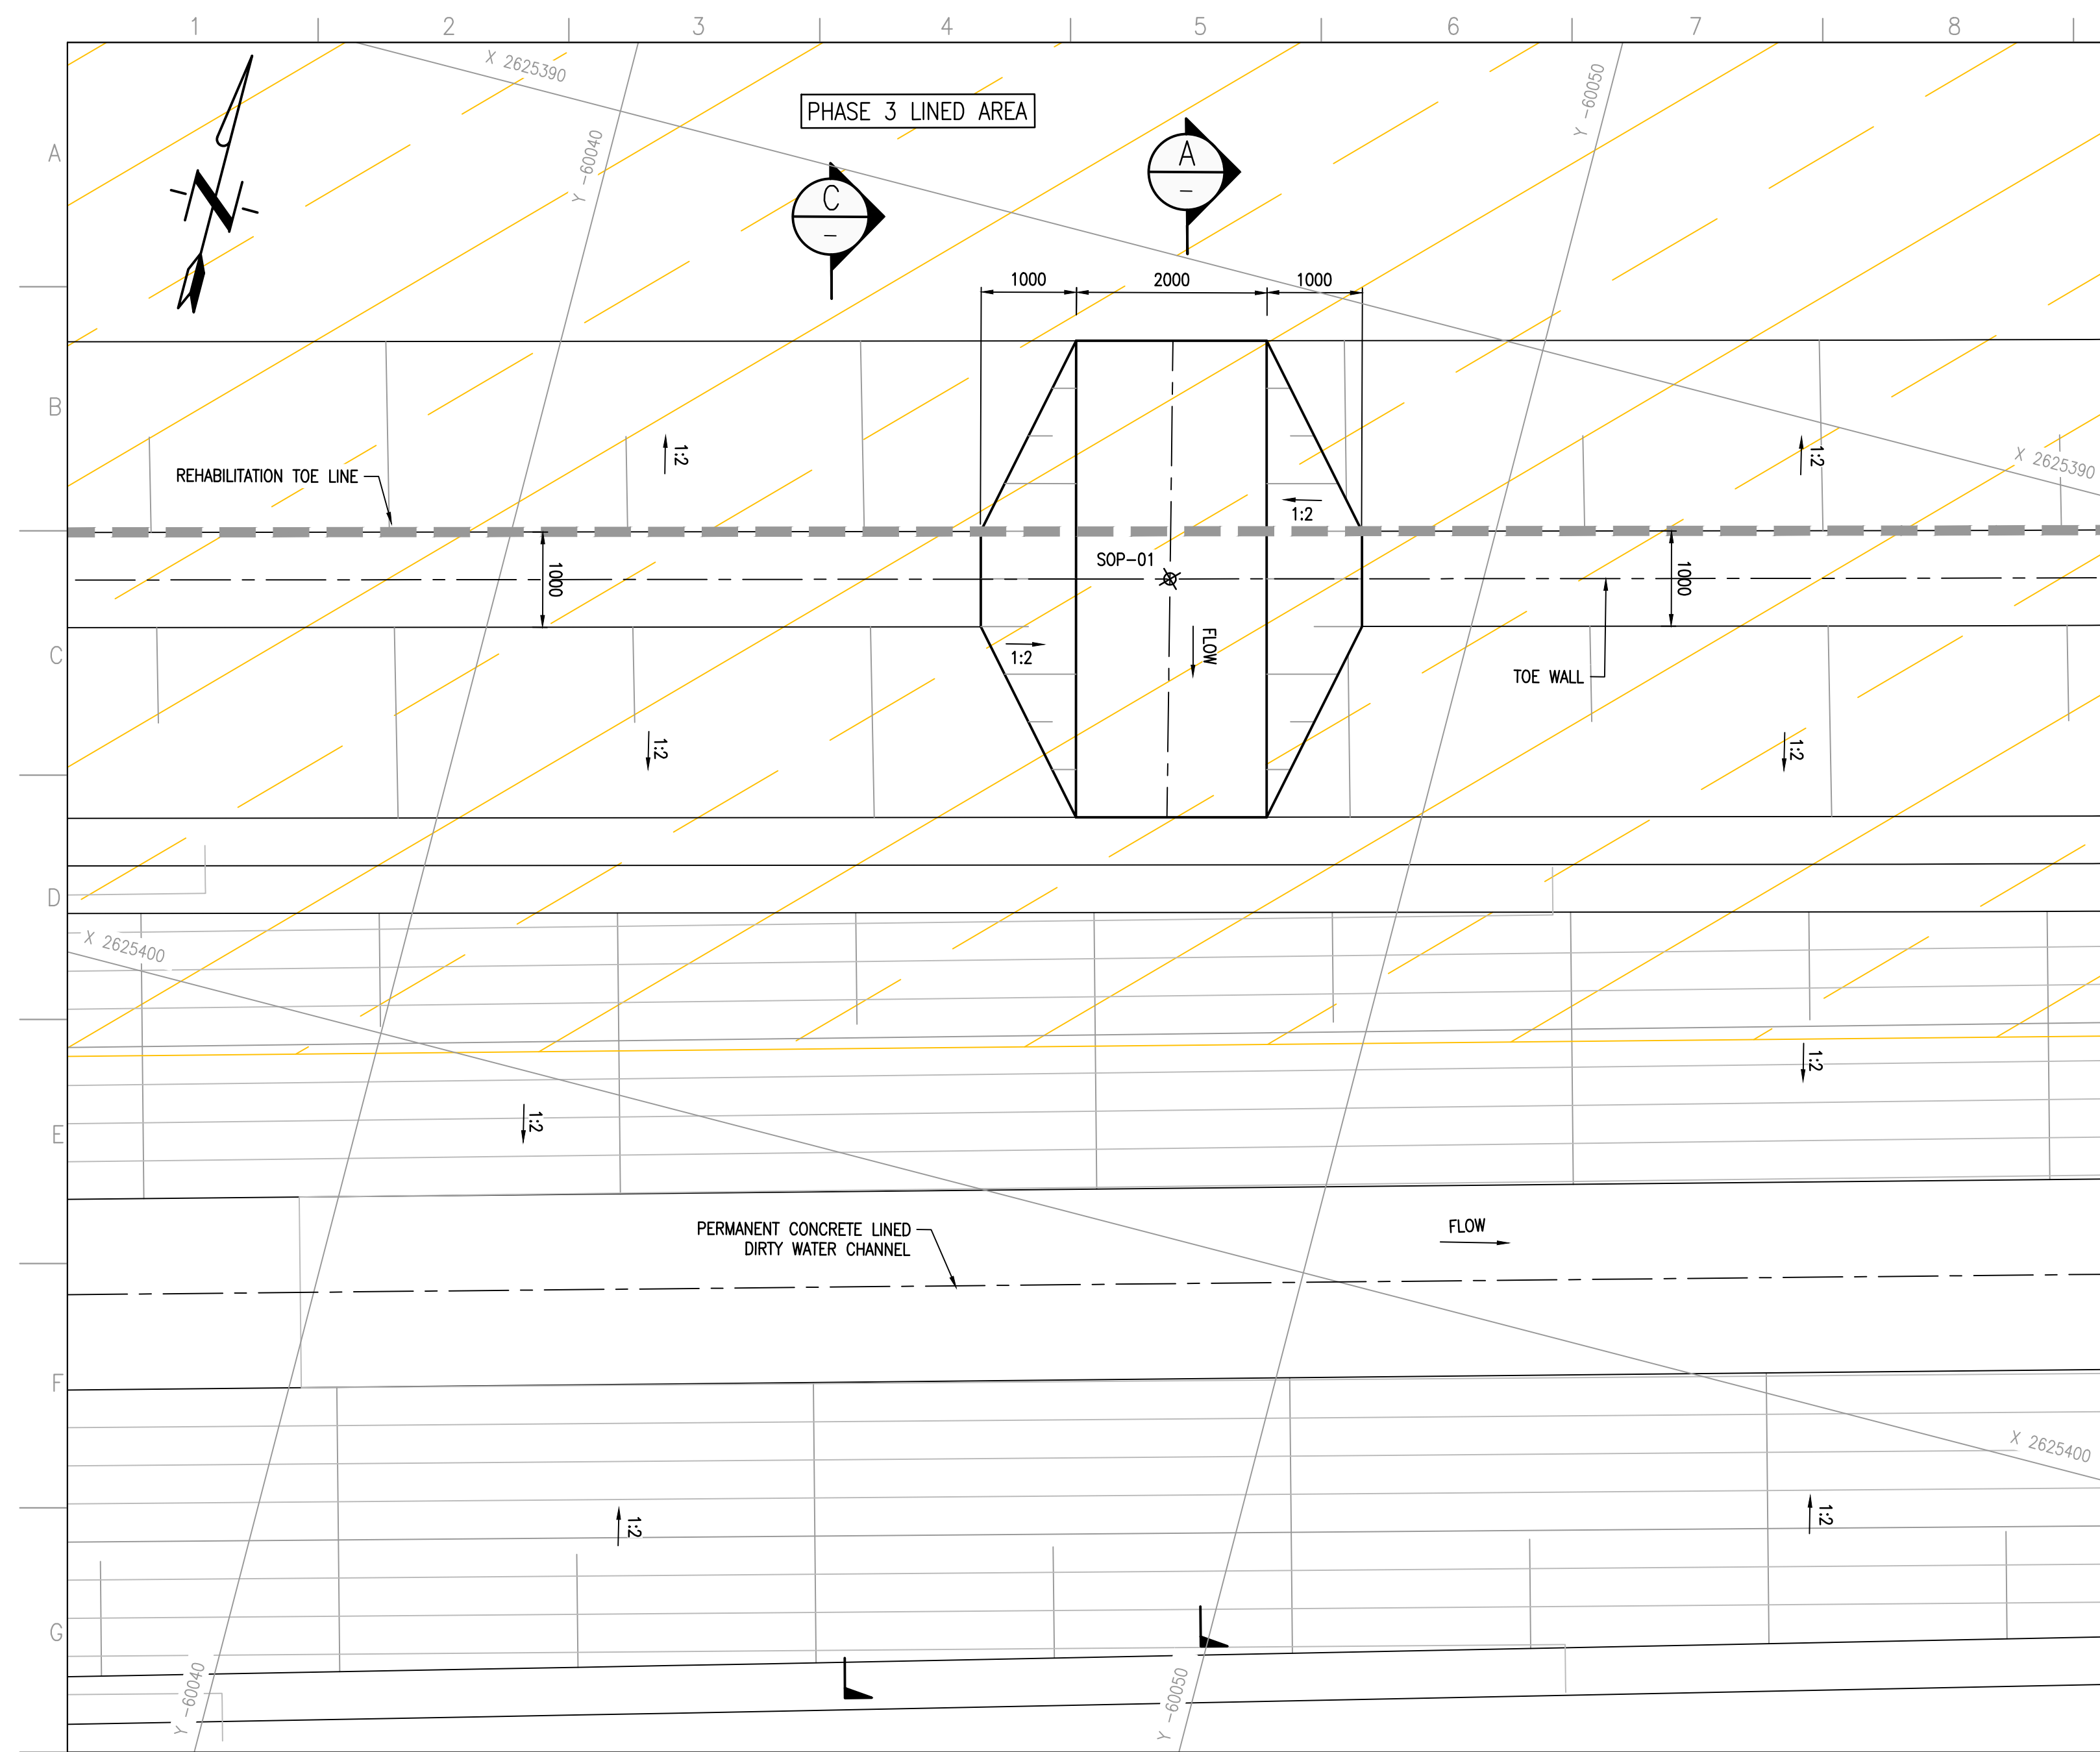


1 SPILLWAY 3A LAYOUT PLAN
SCALE 1:50


SPILLWAYS SETTING OUT DATA (Lo27 WGS84)		
POINT	X	Y
SOP-01	2625393.304	-60046.816
SOP-02	2625335.209	-59962.141

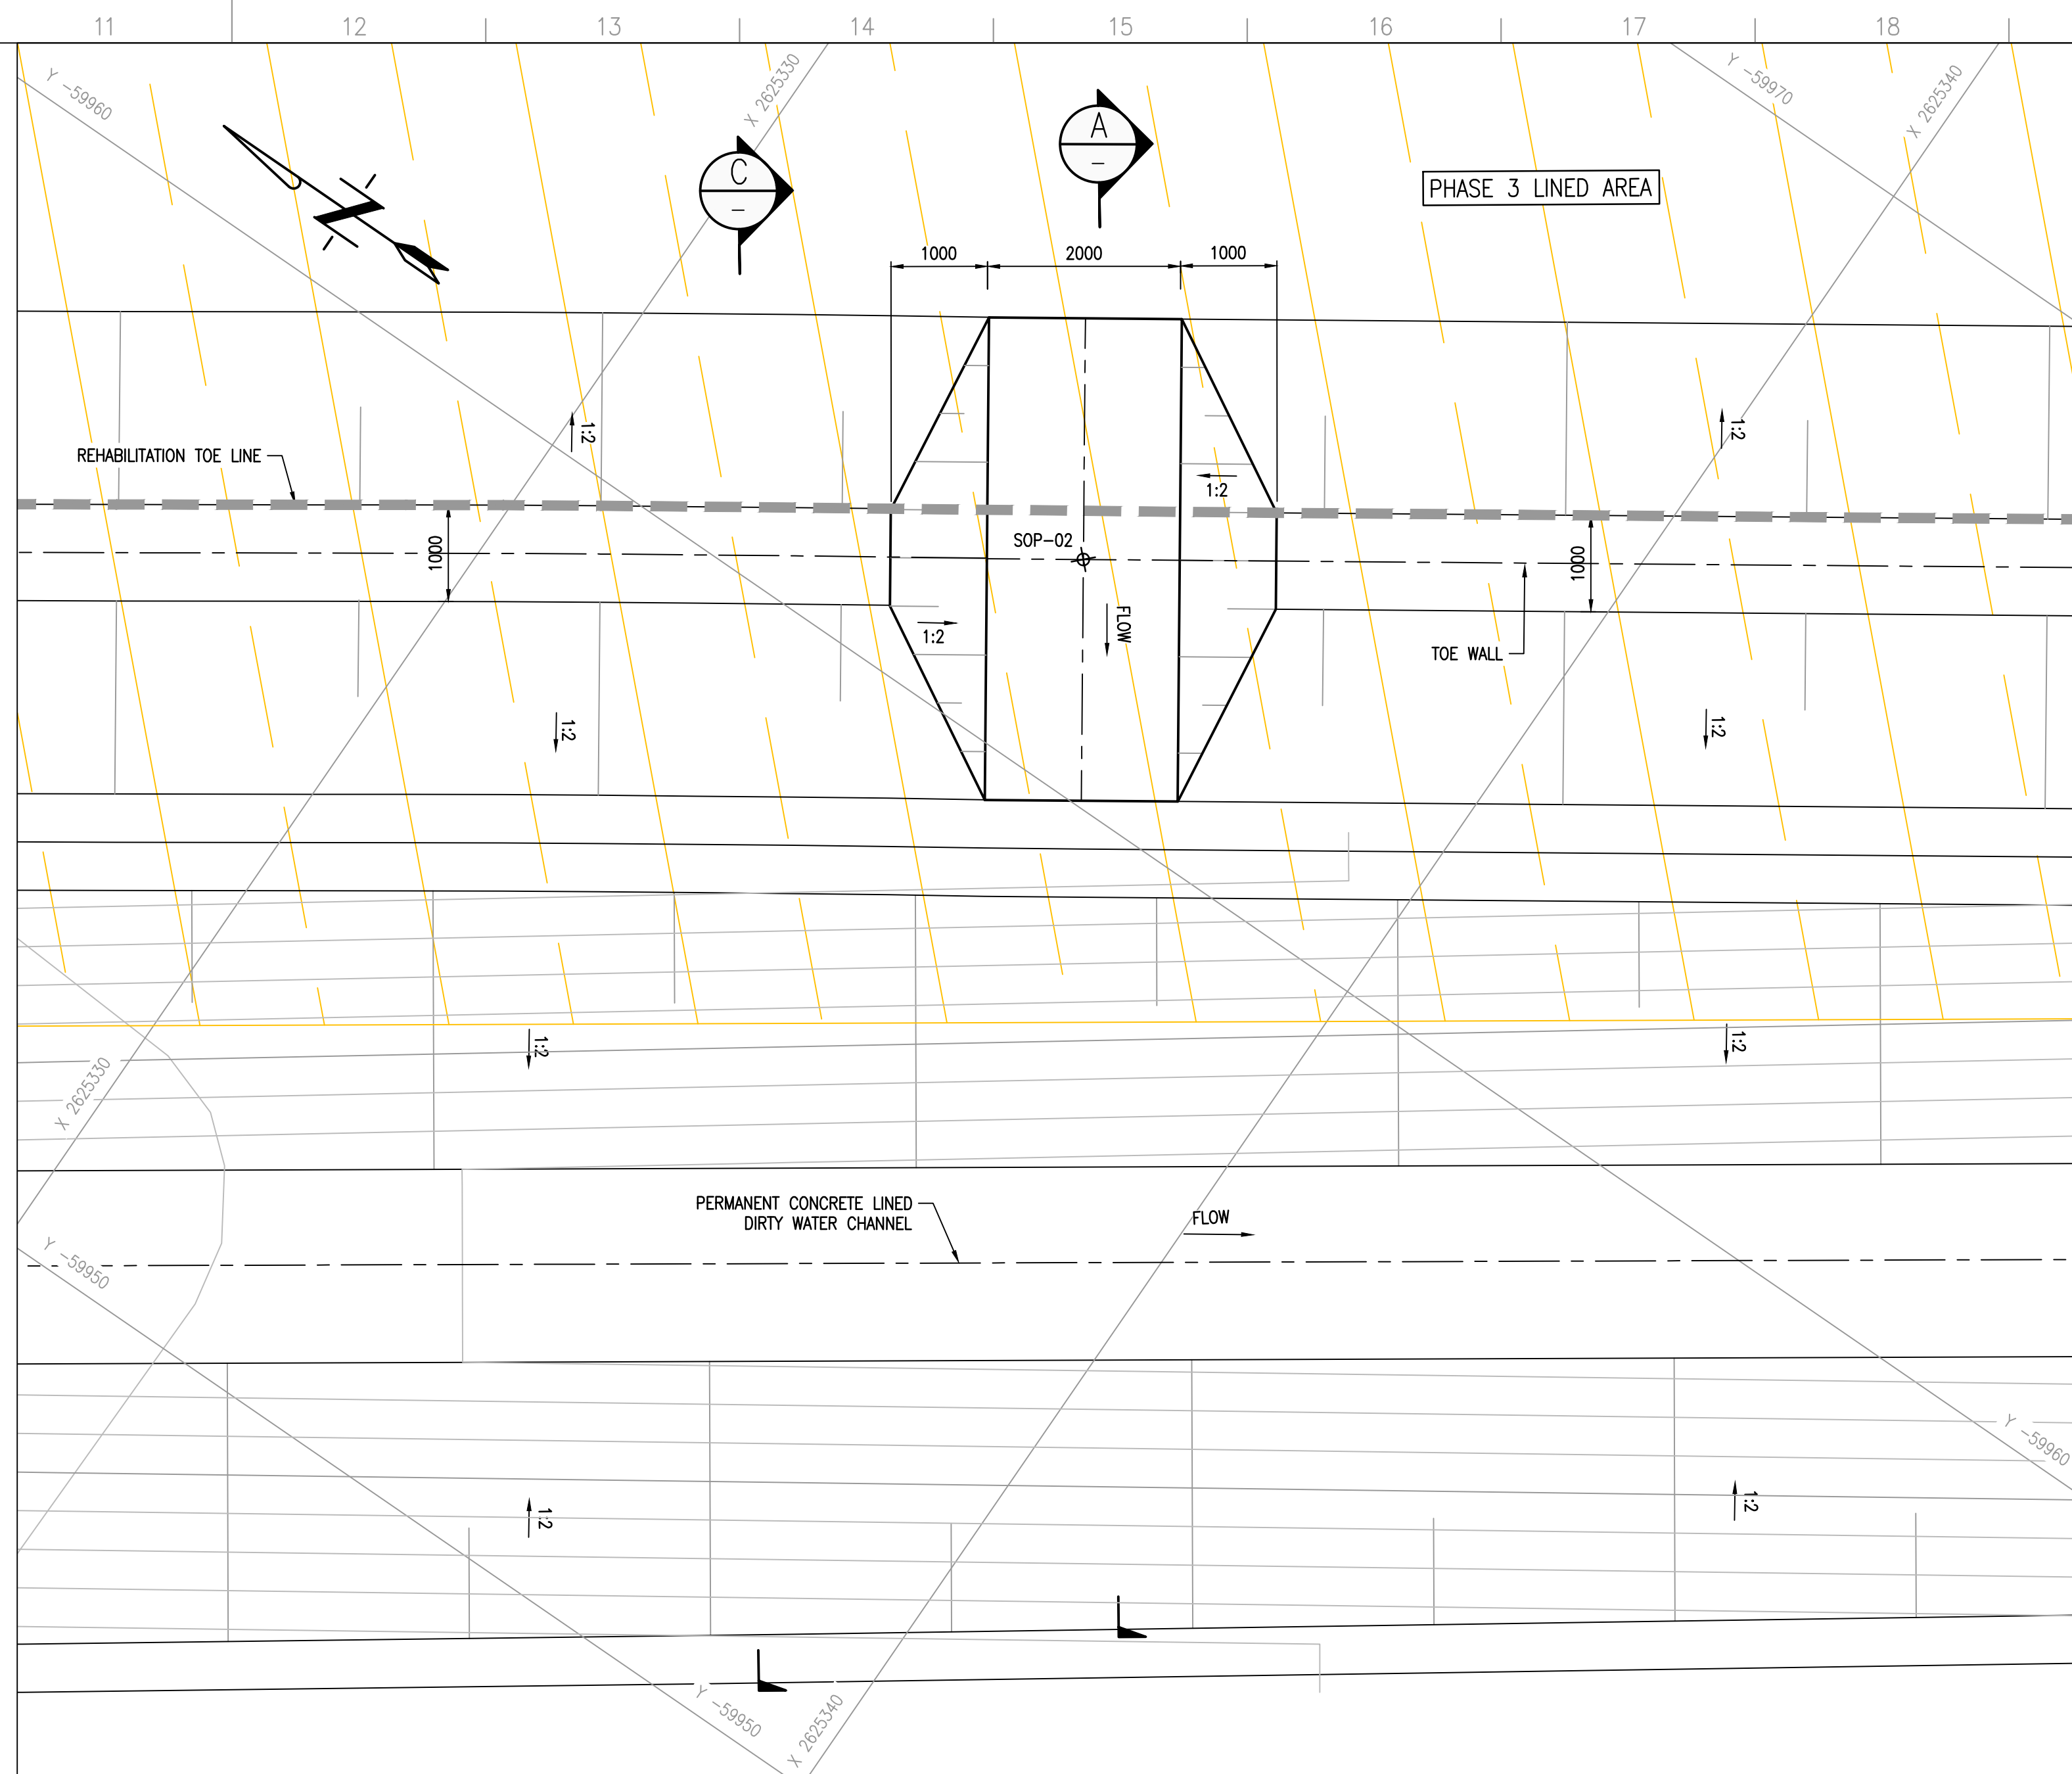


2 SPILLWAY 3B LAYOUT PLAN
SCALE 1:50

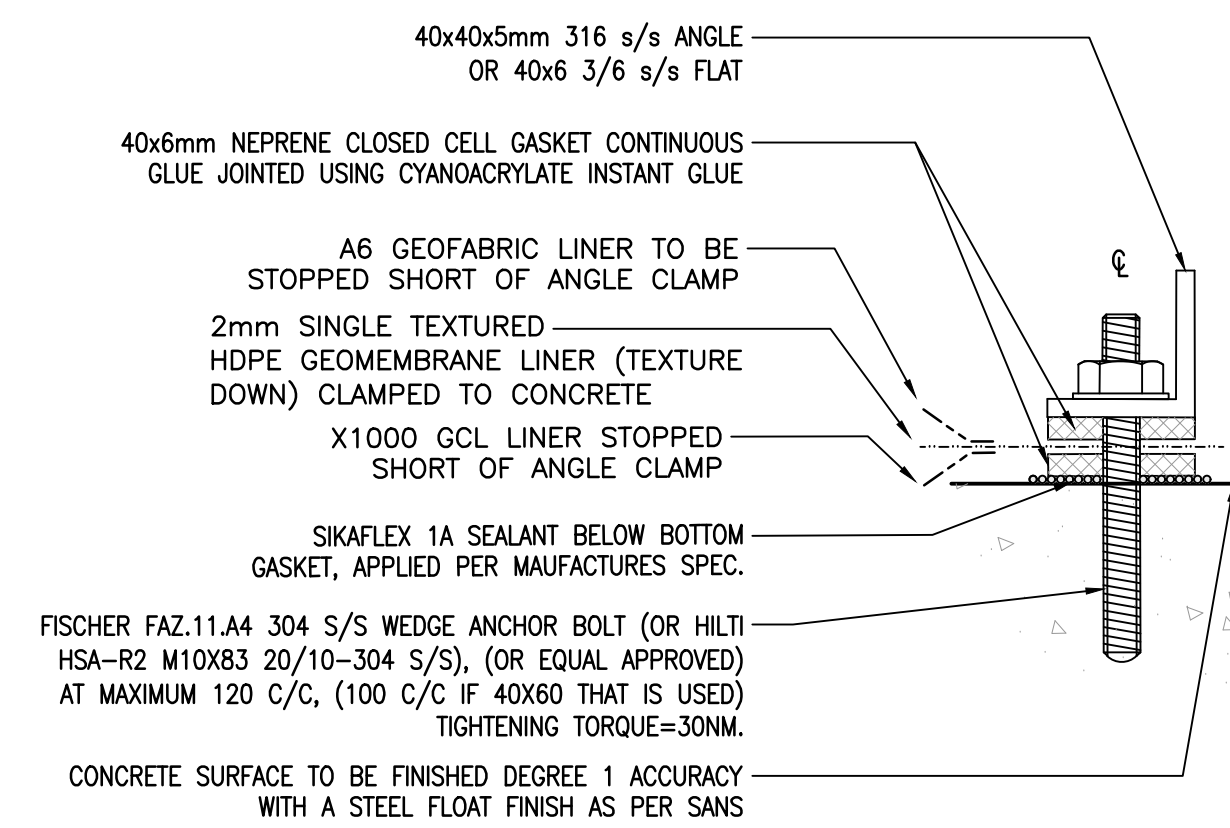


3 LINER SYSTEM FIXING DETAIL
SCALE 1:2

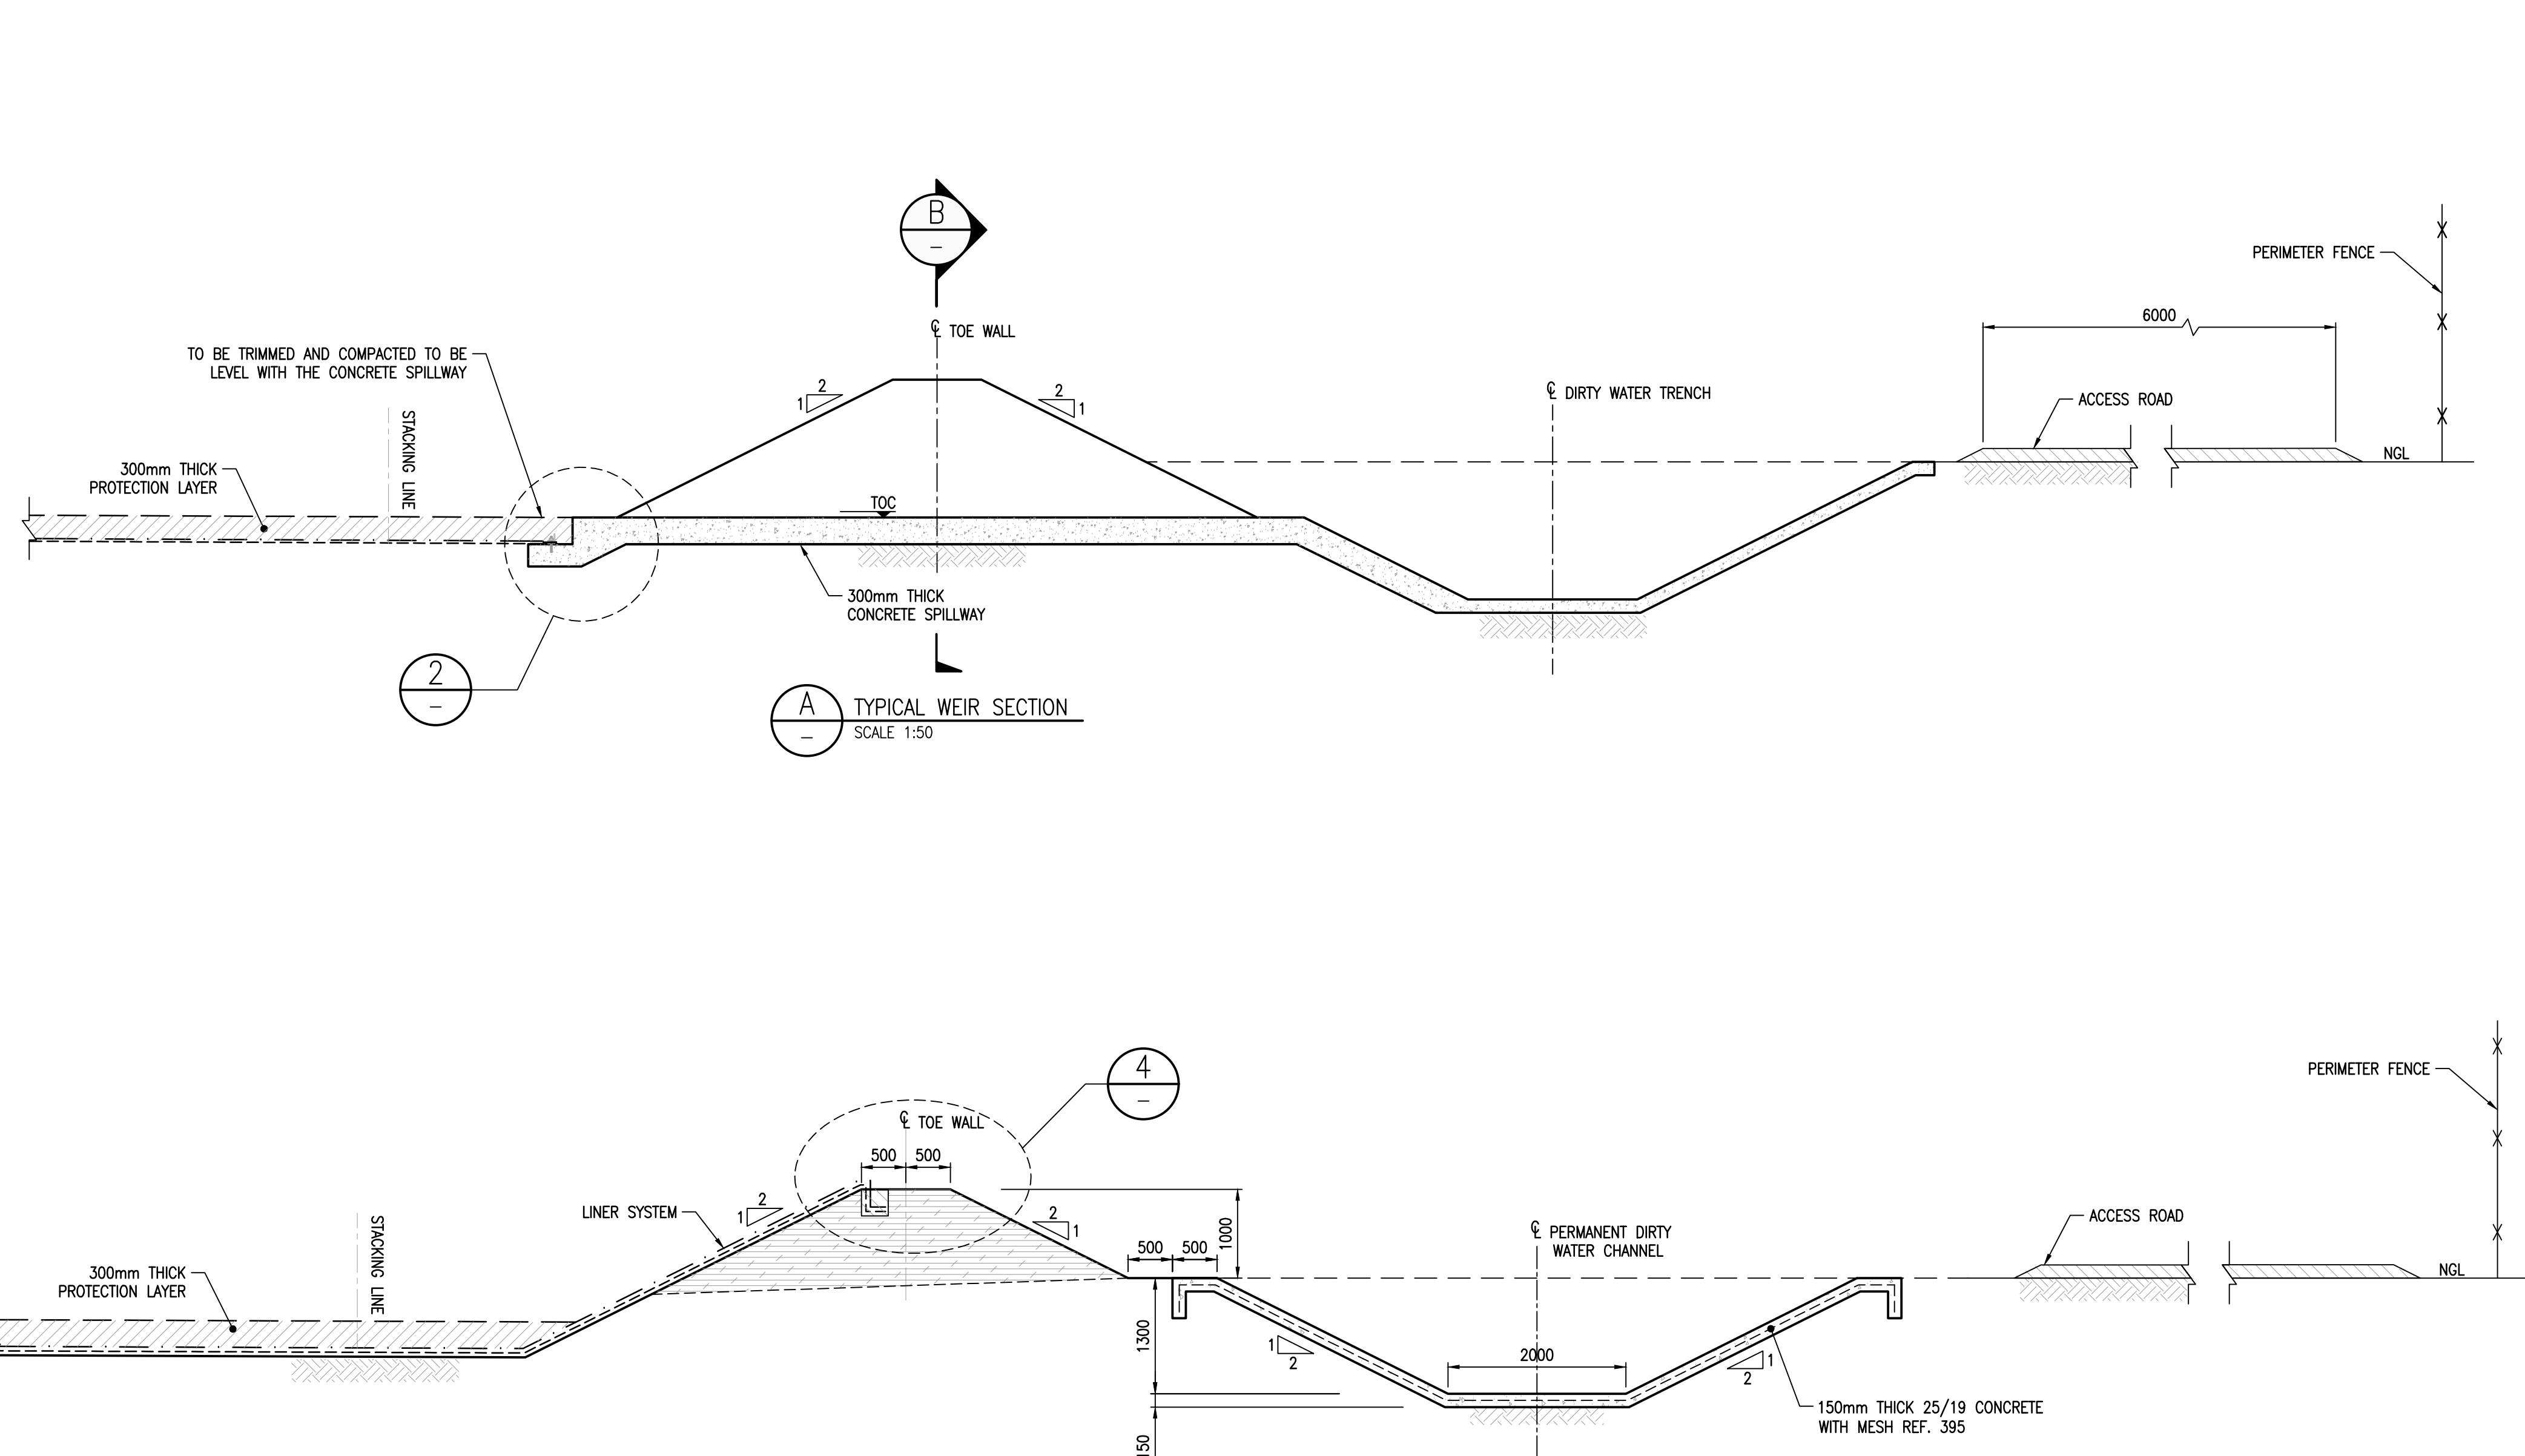


A TYPICAL WEIR SECTION
SCALE 1:50

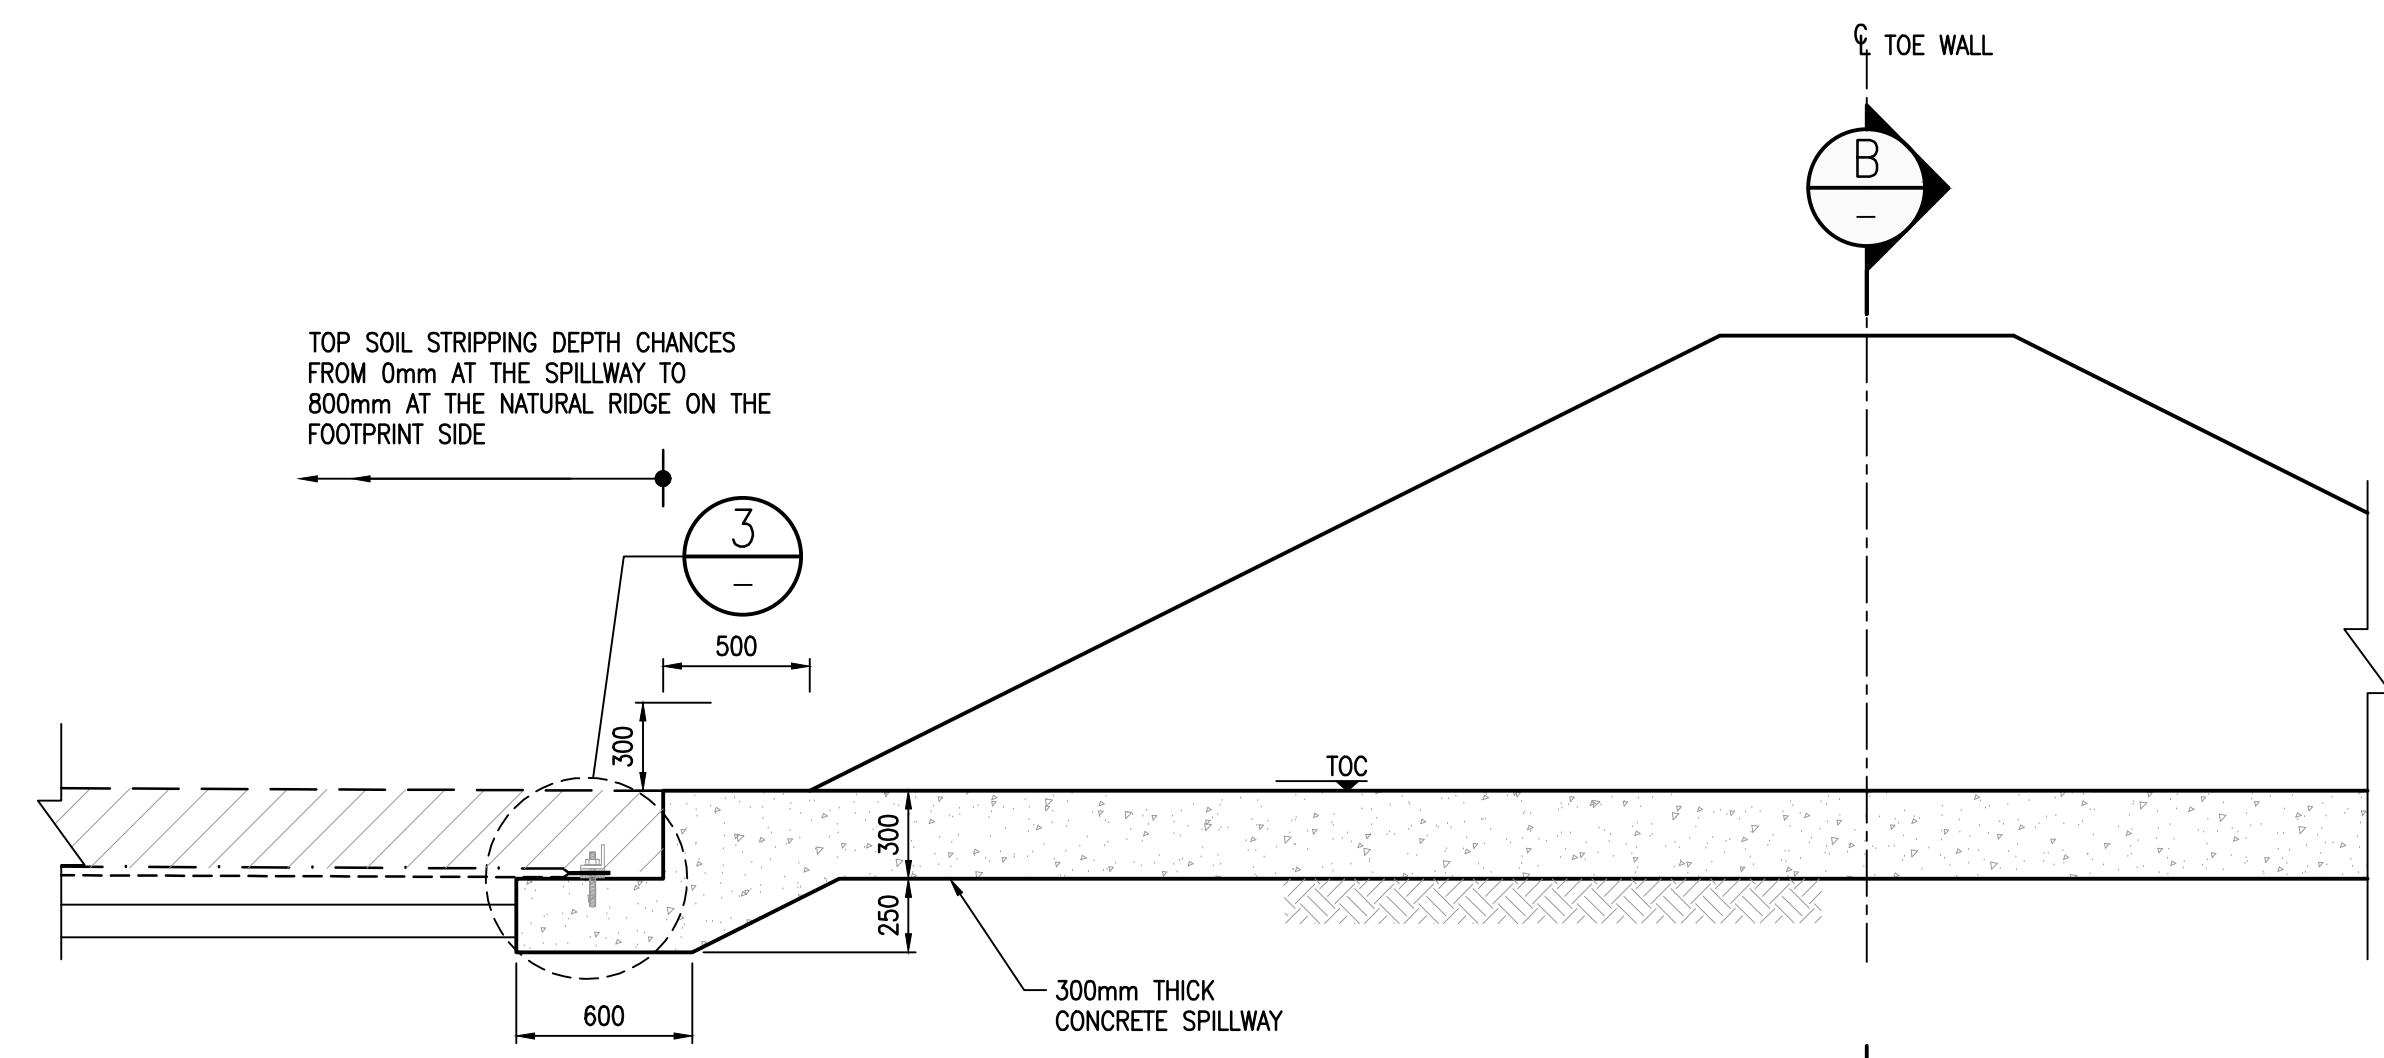


2 TYPICAL DETAIL
SCALE 1:25

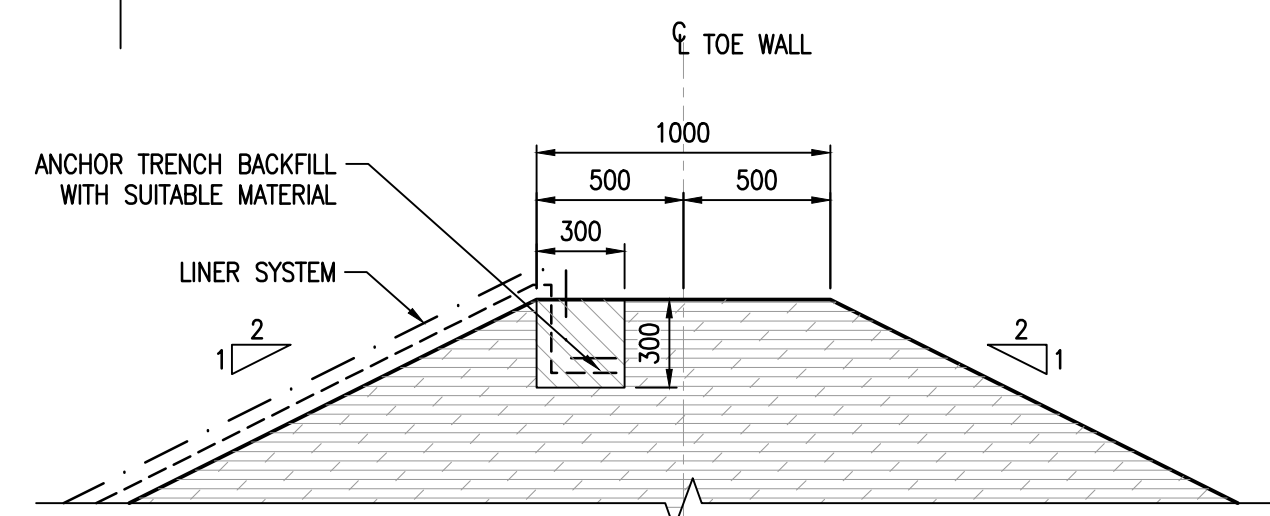

4 ANCHOR TRENCH
SCALE 1:25

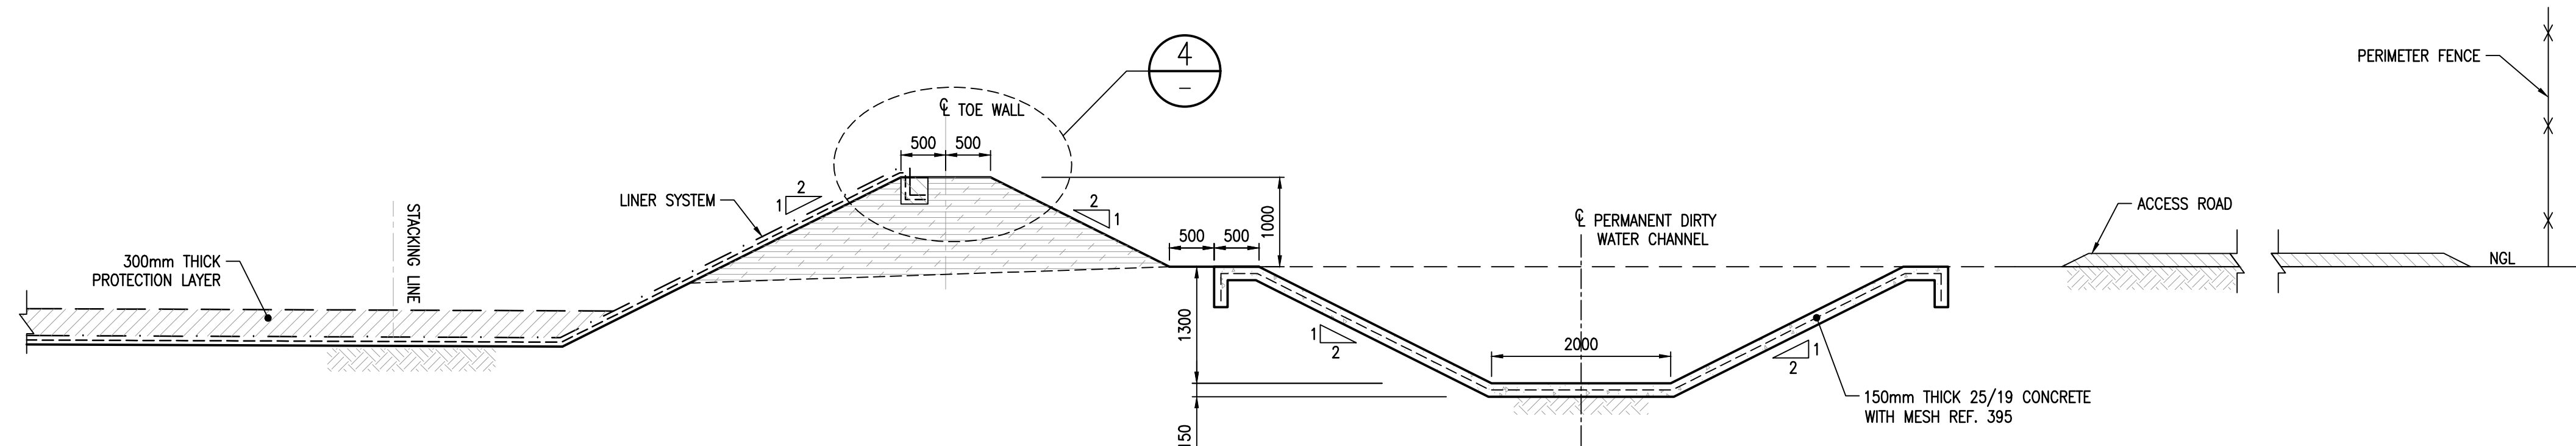

C TYPICAL TOE WALL SECTION
SCALE 1:50

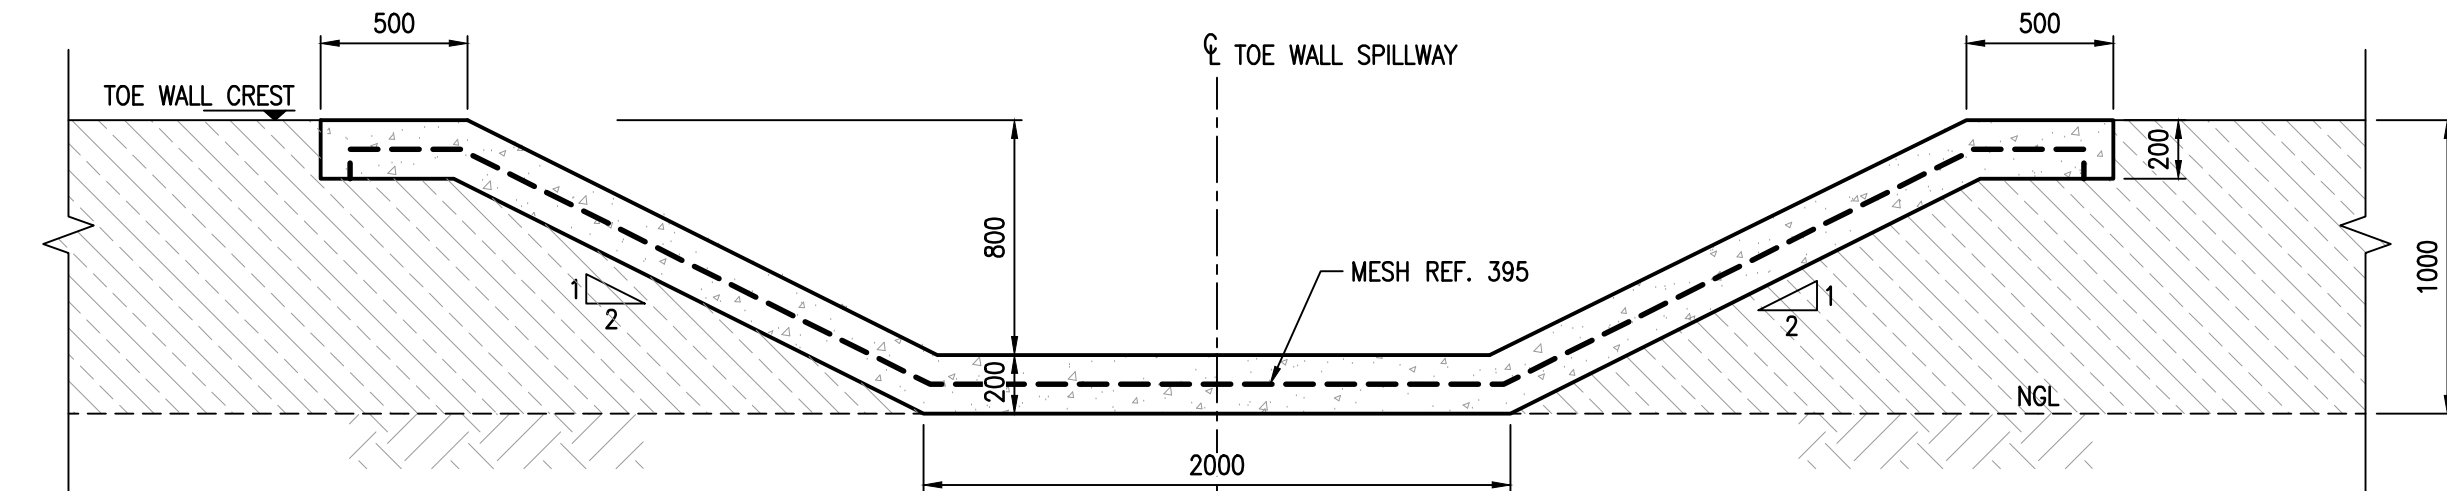

B TYPICAL SPILLWAY SECTION
SCALE 1:25



FOR CONSTRUCTION

DISCLAIMER
This drawing was prepared by Knight Piesold Consulting (Pty) Ltd based on the best information available at the time of preparation. During construction site conditions, or site conditions, or site development, may possibly dictate that amendments of adaptations be made to certain details on the drawing. Strict compliance with the project specifications is also essential. Knight Piesold Consulting (Pty) Ltd will therefore not accept liability for any losses, damages or consequential losses, suffered by any party resulting from the use or implementation of the contents of this drawing, if executed or amended without fulltime supervision by Knight Piesold Consulting (Pty) Ltd.

2 RELEASED FOR CONSTRUCTION				REFERENCE DRAWINGS			
D.O. REV. DATE	REVISION	REV. BY	APP. BY	REV. BY	APP. BY	REV. BY	APP. BY
AUTHORISED FOR ESKOM BY: CLASSIFICATION				PES PATH			
COORDINATION BY:				APPROVED BY:			
CREATED BY:				CREATED BY:			
CREATED BY:				CREATED BY:			
SCALE AS SHOWN				SCALE AS SHOWN			

MATIMBA POWER STATION
MATIMBA ASH DUMP
PHASE 3 (12 YEARS LINED AREA)
SPILLWAYS
LAYOUT PLAN, SECTIONS AND DETAILS

301-00825/01-307
0.58/61416
REV 2
REV 2

DRAWING CLASSIFICATION: CONTROLLED DISCLOSURE